


C:\Users\steve\OneDrive\Desktop\PROJECTS\SHELBY CITY CT-HSE PERMIT SET.dwg, 8/14/2026 3:02:44 PM

ARCHITECTURAL SYMBOL LEGEND

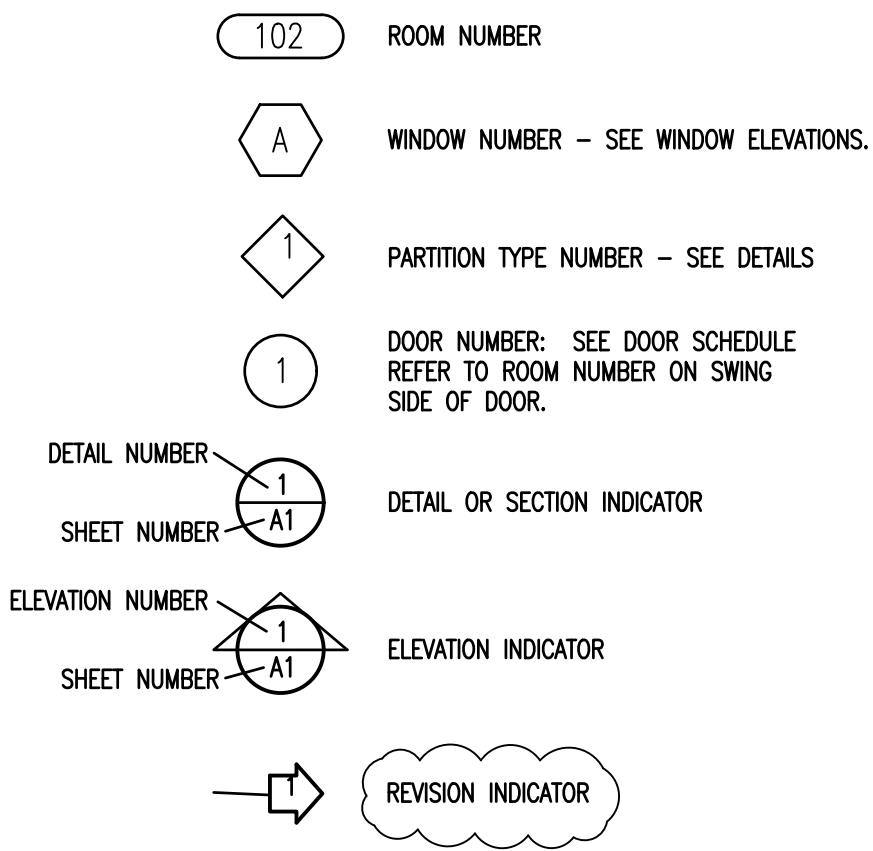

SCOPE OF WORK AT COURTROOM AND HALLWAY BY OWNER:

- REMOVE AND STORE GALLERY BENCHES TO BE REINSTALLED.
- REMOVE ALL EXISTING PLATFORMS, RAMPS, STEPS, RAILINGS.
- REMOVE JUDGES BENCH, WITNESS STAND, COURT REPORTERS STAND
- REMOVE COURT BAR RAILS, COUNTERTOPS, JURY SEATING.
- REMOVE ALL ASSOCIATED ELECTRICAL AND DATA WIRING AND DEVICES.
- REMOVE 2 STEPS AND PLATFORM IN HALLWAY ENTRANCE TO COURTROOM.
- REMOVE CARPET TILES.
- INSTALL VINYL WALL FABRIC AT COURTROOM CEILING BULKHEAD.
- INSTALL VINYL WALL FABRIC IN HALLWAY.
- FURNISH CARPET TILES FOR COURTROOM AND DOOR LANDING.
- PAINT DOOR FRAMES.
- REFURBISH WOOD DOORS IF REQUIRED.
- INSTALL POWER AND DATA AT COURTROOM BUILT-IN FURNISHINGS.
- REPLACE TROFFER LIGHTING FIXTURES AS REQUIRED.
- REMOVE EXISTING COURTROOM DOOR AT HALLWAY AND REPLACE WITH TALLER DOOR AND FRAME.
- INSTALL COURTROOM FURNISHINGS IE. TABLES, CHAIRS, GALLERY BENCHES.

SCOPE OF WORK AT COURTROOM AND HALLWAY BY CONTRACTOR:

- PROVIDE FRAMED PLATFORMS, RAMPS, PARTIAL HEIGHT WALLS / RAILS.
- PROVIDE (3) BAR GATES, 2 WITH DOUBLE ACTION BARREL HINGES AND 1 WITH SINGLE ACTION.
- PROVIDE STAINLESS STEEL HANDRAILS AT RAMPS AND STEPS (BOTH COURTROOM AND HALLWAY)
- PROVIDE ACRYLIC PANELS AND ALUMINUM FRAMING AT JURY BOX.
- PROVIDE CASEWORK AND MILLWORK FOR COURTROOM BUILT-IN FURNISHINGS.
- PROVIDE FINISHED WOOD AND GRANITE COUNTERTOPS.
- PROVIDE STAINED AND FINISHED WALL PANELS WHERE NEW PLATFORMS ARE LOWER THAN EXISTING.
- STAINED AND FINISHED HARDWOOD TO MATCH EXISTING MAHOGANY PANELING.
- INSTALL CARPET TILES AT COURTROOM AND DOOR LANDING.
- FURNISH AND INSTALL RUBBER COVE BASE AT DOOR LANDING (NONE IN COURTROOM)
- FURNISH AND INSTALL JURY BOX SEATING AND REQUIRED PLATFORM BLOCKING.

FLOOR AND WALL FINISHES FURNISHED AND INSTALLED BY OWNER

VINYL WALL FABRIC: MDC MODERN INDUSTRY GUNMETAL 3063 MI / 4131

DOORS AND FRAMES PAINT: SW 7020 "BLACK FOX" SEMI-GLOSS

CORNER GUARDS: IPC 150 3" X 8' "PEPPERDUST" 0119. INSTALL AT CORRIDOR OUTSIDE CORNERS.

FLOOR AND WALL FINISHES FURNISHED BY OWNER AND INSTALLED BY CONTRACTOR

CARPET TILES: INTERFACE STYLE: EARTH II COLOR: PLATEAU

FLOOR AND WALL FINISHES FURNISHED AND INSTALLED BY CONTRACTOR

RUBBER BASE : 4" OR 6" COVE COLOR AND HEIGHT TO MATCH EXISTING

ARCH. DRAWING INDEX

- CS COVER SHEET
- A1 FLOOR PLAN
- A2 FURNISHINGS PLAN
- A3 DIMENSION PLAN
- A4 COURTROOM DETAILS
- A5 COURTROOM DETAILS
- A6 ELEC. AND DATA LAYOUT

7 TOTAL ARCHITECTURAL SHEETS

BIDS FOR CONSTRUCTION SET 8-17-2026

Project Name and Address:

Courtroom 2A Renovation
Shelby County Courthouse
112 North Main Street
Columbiana, Alabama 35051


Drawing scale indicated is accurate on 24"x36" sheets only

REVISIONS	BY

DRAWINGS COPYRIGHT ©2026
ALL RIGHTS RESERVED
Stephen Coker Architect LLC



Courtroom 2A Renovation
Shelby County Courthouse
112 North Main Street
Columbiana, Alabama 35051

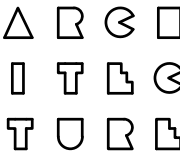

Stephen
Coker
Architect

LLC

1000 Glen View Road
Birmingham, Alabama 35222

Phone 205/595-0021


E-mail:
steve@cokerarch.com

DRAWING DATE	8-17-2026
DRAWN BY	SJC
PROJECT NO.	160816



SHEET NO.
CS
1 OF 7 SHEETS

C:\Users\steve\OneDrive\Desktop\PROJECTS\SHELBY CTY CT-HSE\SHELBY CTY CT-HSE PERMIT SET.dwg, 8/14/2026 3:02:46 PM

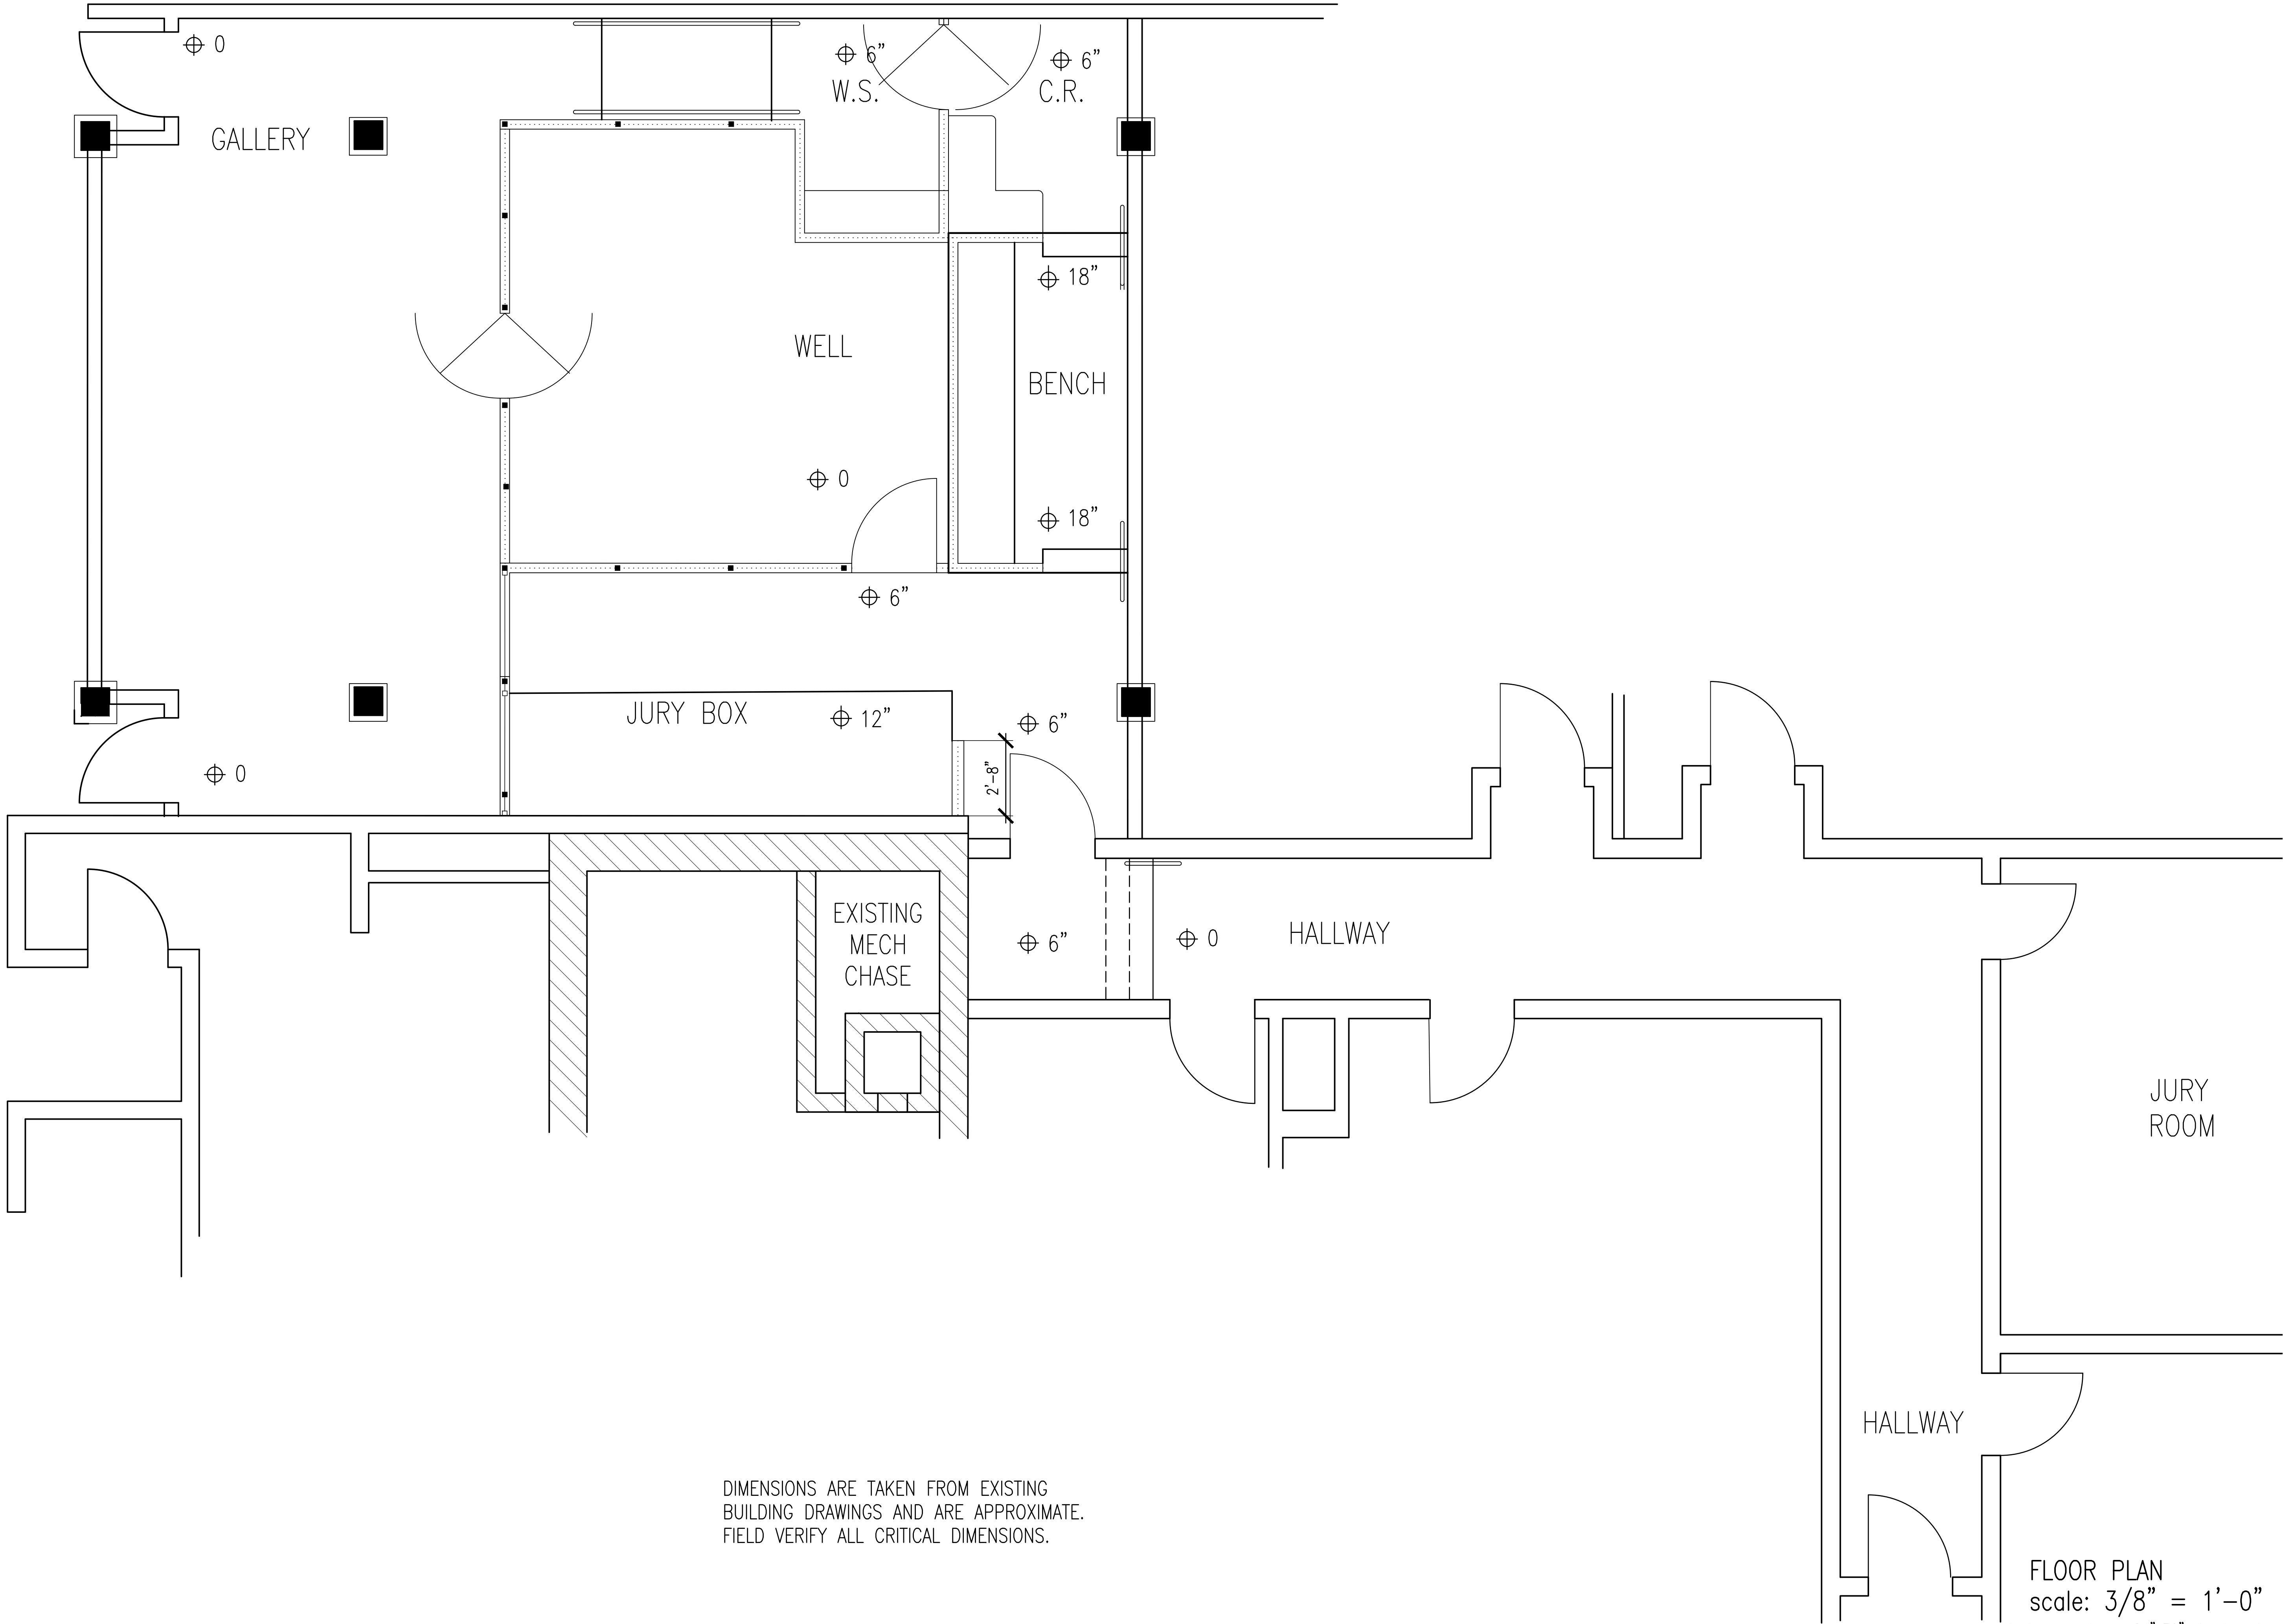


REVISIONS	BY

DRAWINGS COPYRIGHT © 2026
ALL RIGHTS RESERVED
Stephen Coker Architect LLC



Courtroom 2A Renovation
Shelby County Courthouse
112 North Main Street
Columbiana, Alabama 35051

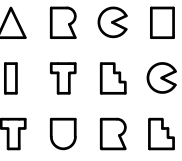

Stephen
Coker
Architect
LLC

1000 Glen View Road
Birmingham, Alabama 35222

Phone 205/595-0021

E-mail:
steve@cokerarch.com


DRAWING DATE	8-17-2026
DRAWN BY	SJC
PROJECT NO.	160816



SHEET NO.
A1
2 OF 7 SHEETS

FLOOR PLAN
scale: 3/8" = 1'-0"
scale is accurate on 24"x36" sheets only

C:\Users\steve\OneDrive\Desktop\PROJECTS\SHELBY CTY CT-HSE\SHELBY CTY CT-HSE PERMIT SET.dwg, 8/14/2026 3:02:49 PM

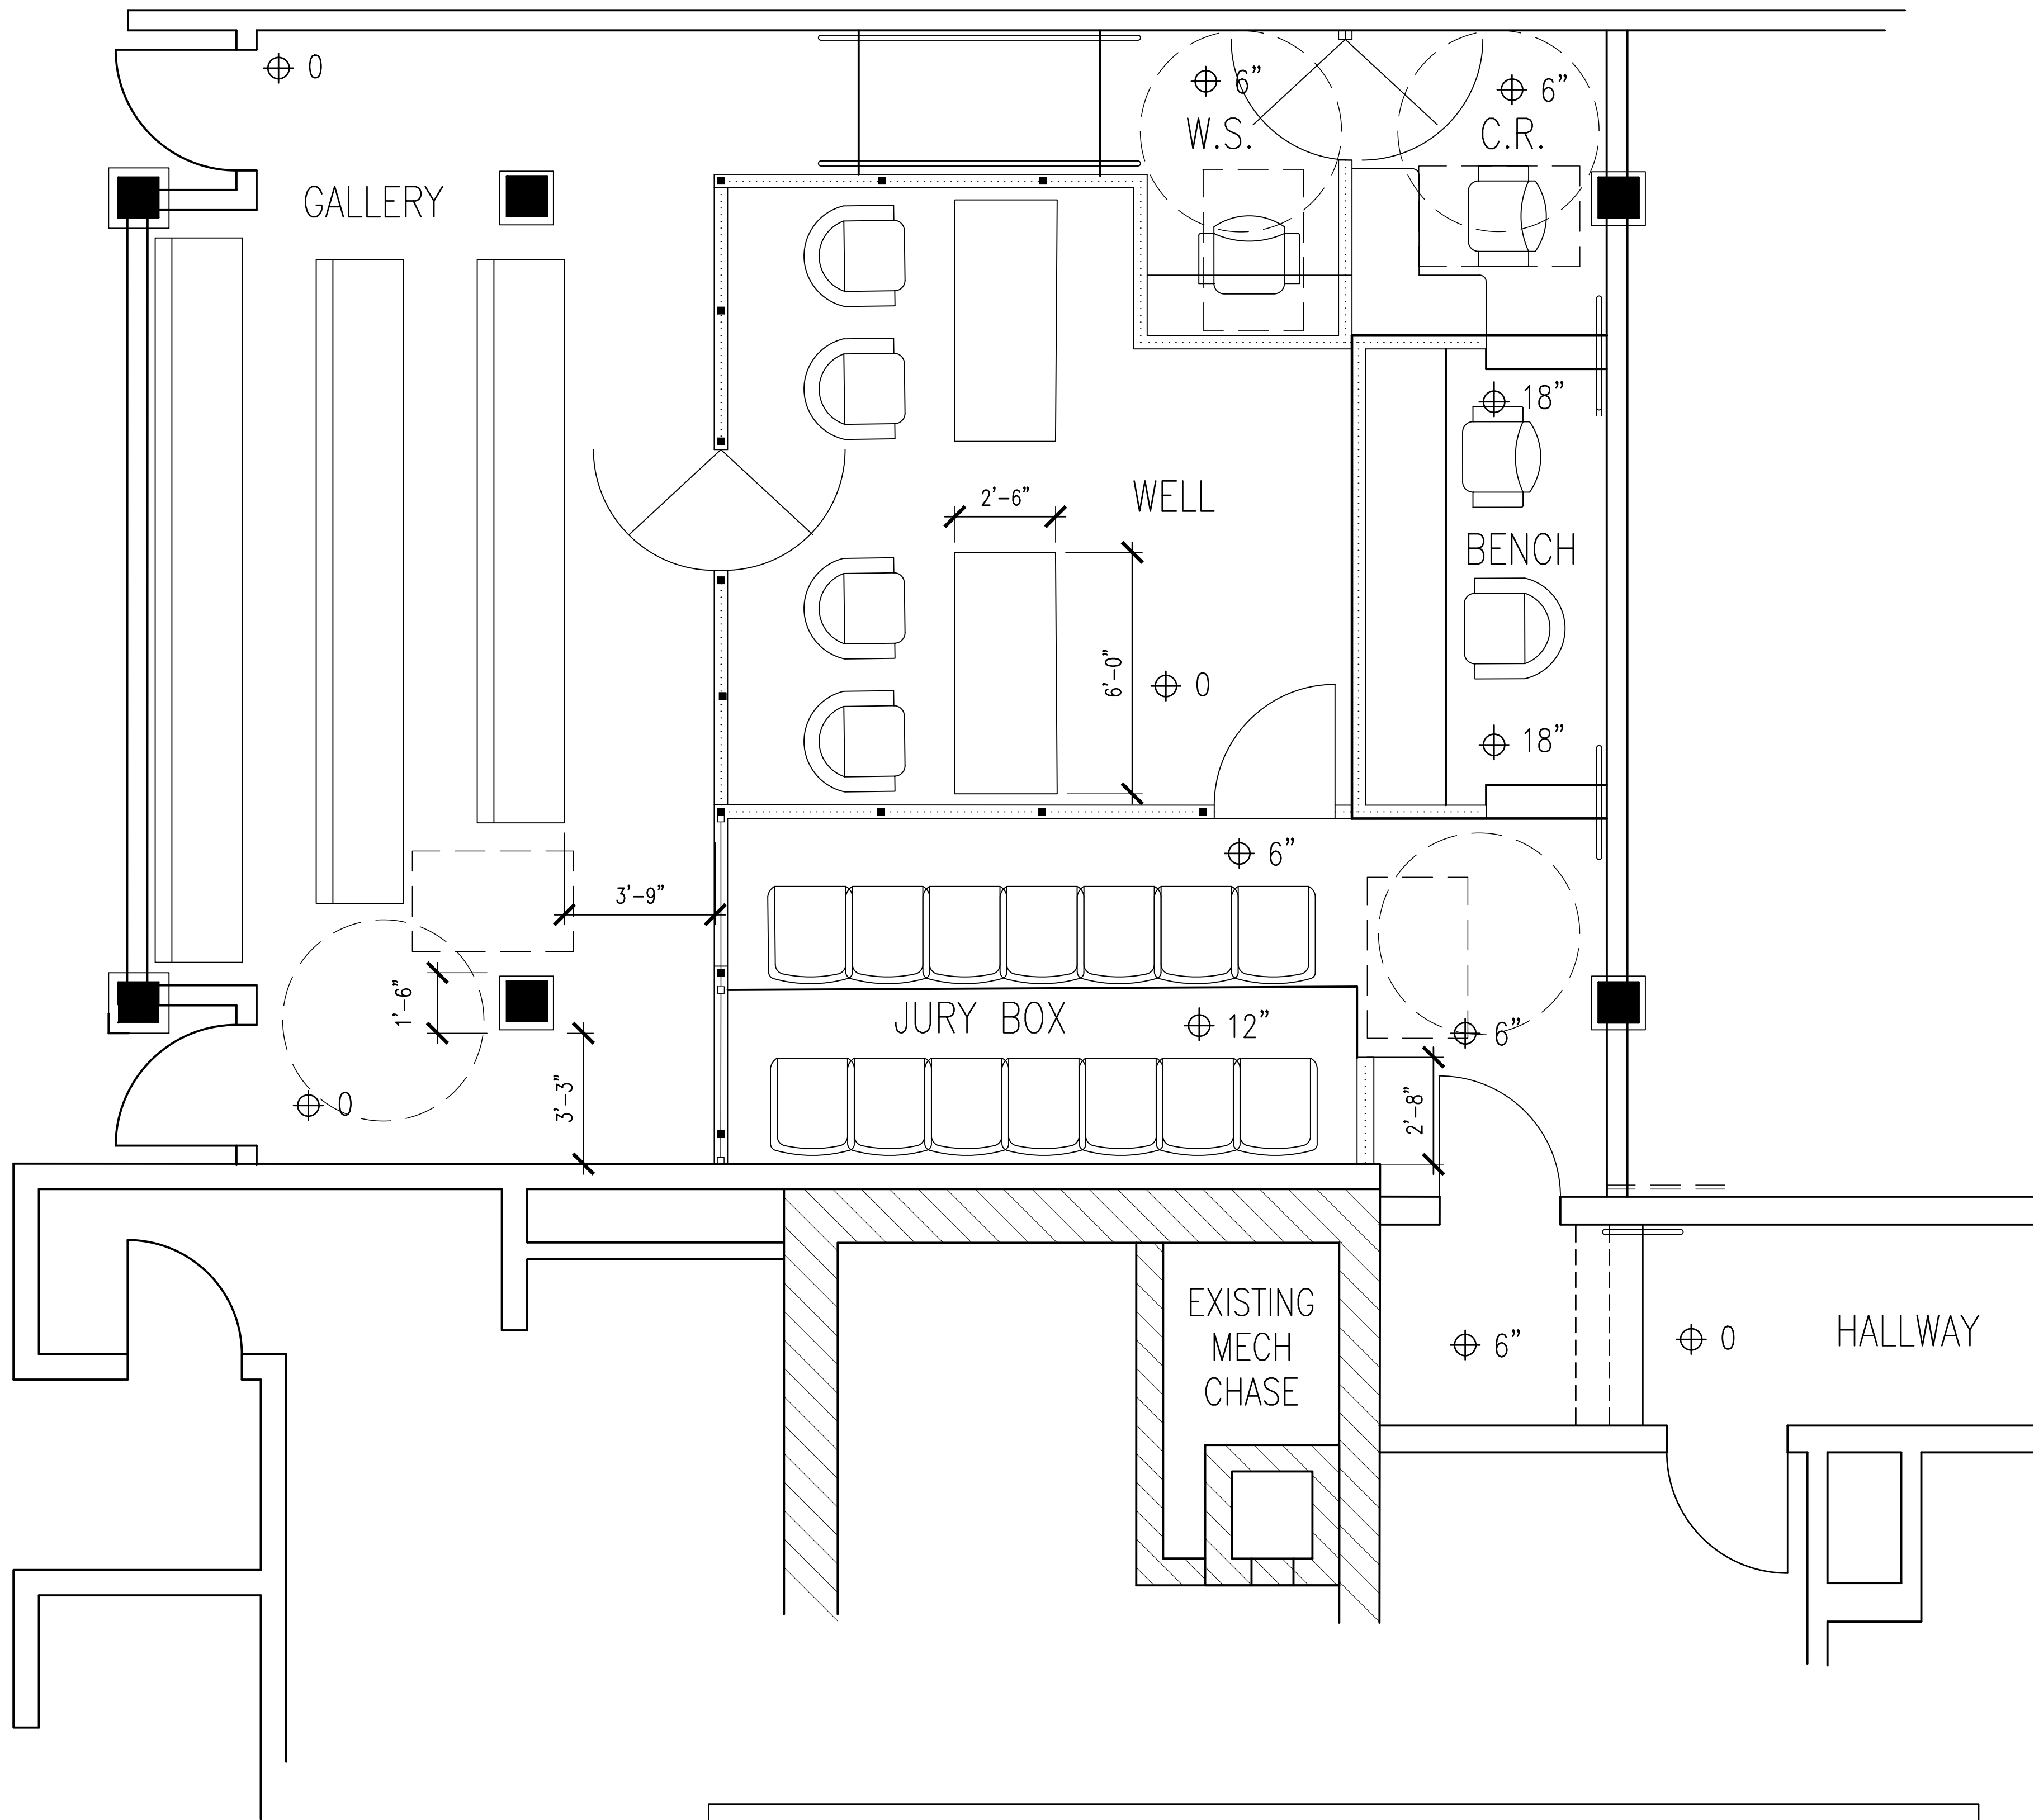

DIMENSIONS ARE TAKEN FROM EXISTING BUILDING DRAWINGS AND ARE APPROXIMATE. FIELD VERIFY ALL CRITICAL DIMENSIONS.

JURY BOX SEATING FURNISHED AND INSTALLED BY CONTRACTOR. DESKS, CHAIRS, AND BENCHES FURNISHED AND INSTALLED BY OWNER.


FURNISHINGS PLAN
scale: 3/8" = 1'-0"
scale is accurate on 24"x36" sheets only

REVISIONS	BY

DRAWINGS COPYRIGHT © 2026
ALL RIGHTS RESERVED
Stephen Coker Architect LLC



Courtroom 2A Renovation
Shelby County Courthouse
112 North Main Street
Columbiana, Alabama 35051

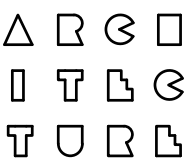

Stephen
Coker
Architect
LLC

1000 Glen View Road
Birmingham, Alabama 35222

Phone 205/595-0021


E-mail:
steve@cokerarch.com

DRAWING DATE	8-17-2026
DRAWN BY	SJC
PROJECT NO.	160816



SHEET NO.
A2
3 OF 7 SHEETS

C:\Users\steve\OneDrive\Desktop\PROJECTS\SHELBY CTY CT-HSE\PROJECTS\SHELBY CTY CT-HSE PERMIT SET.dwg, 8/14/2026 3:02:59 PM

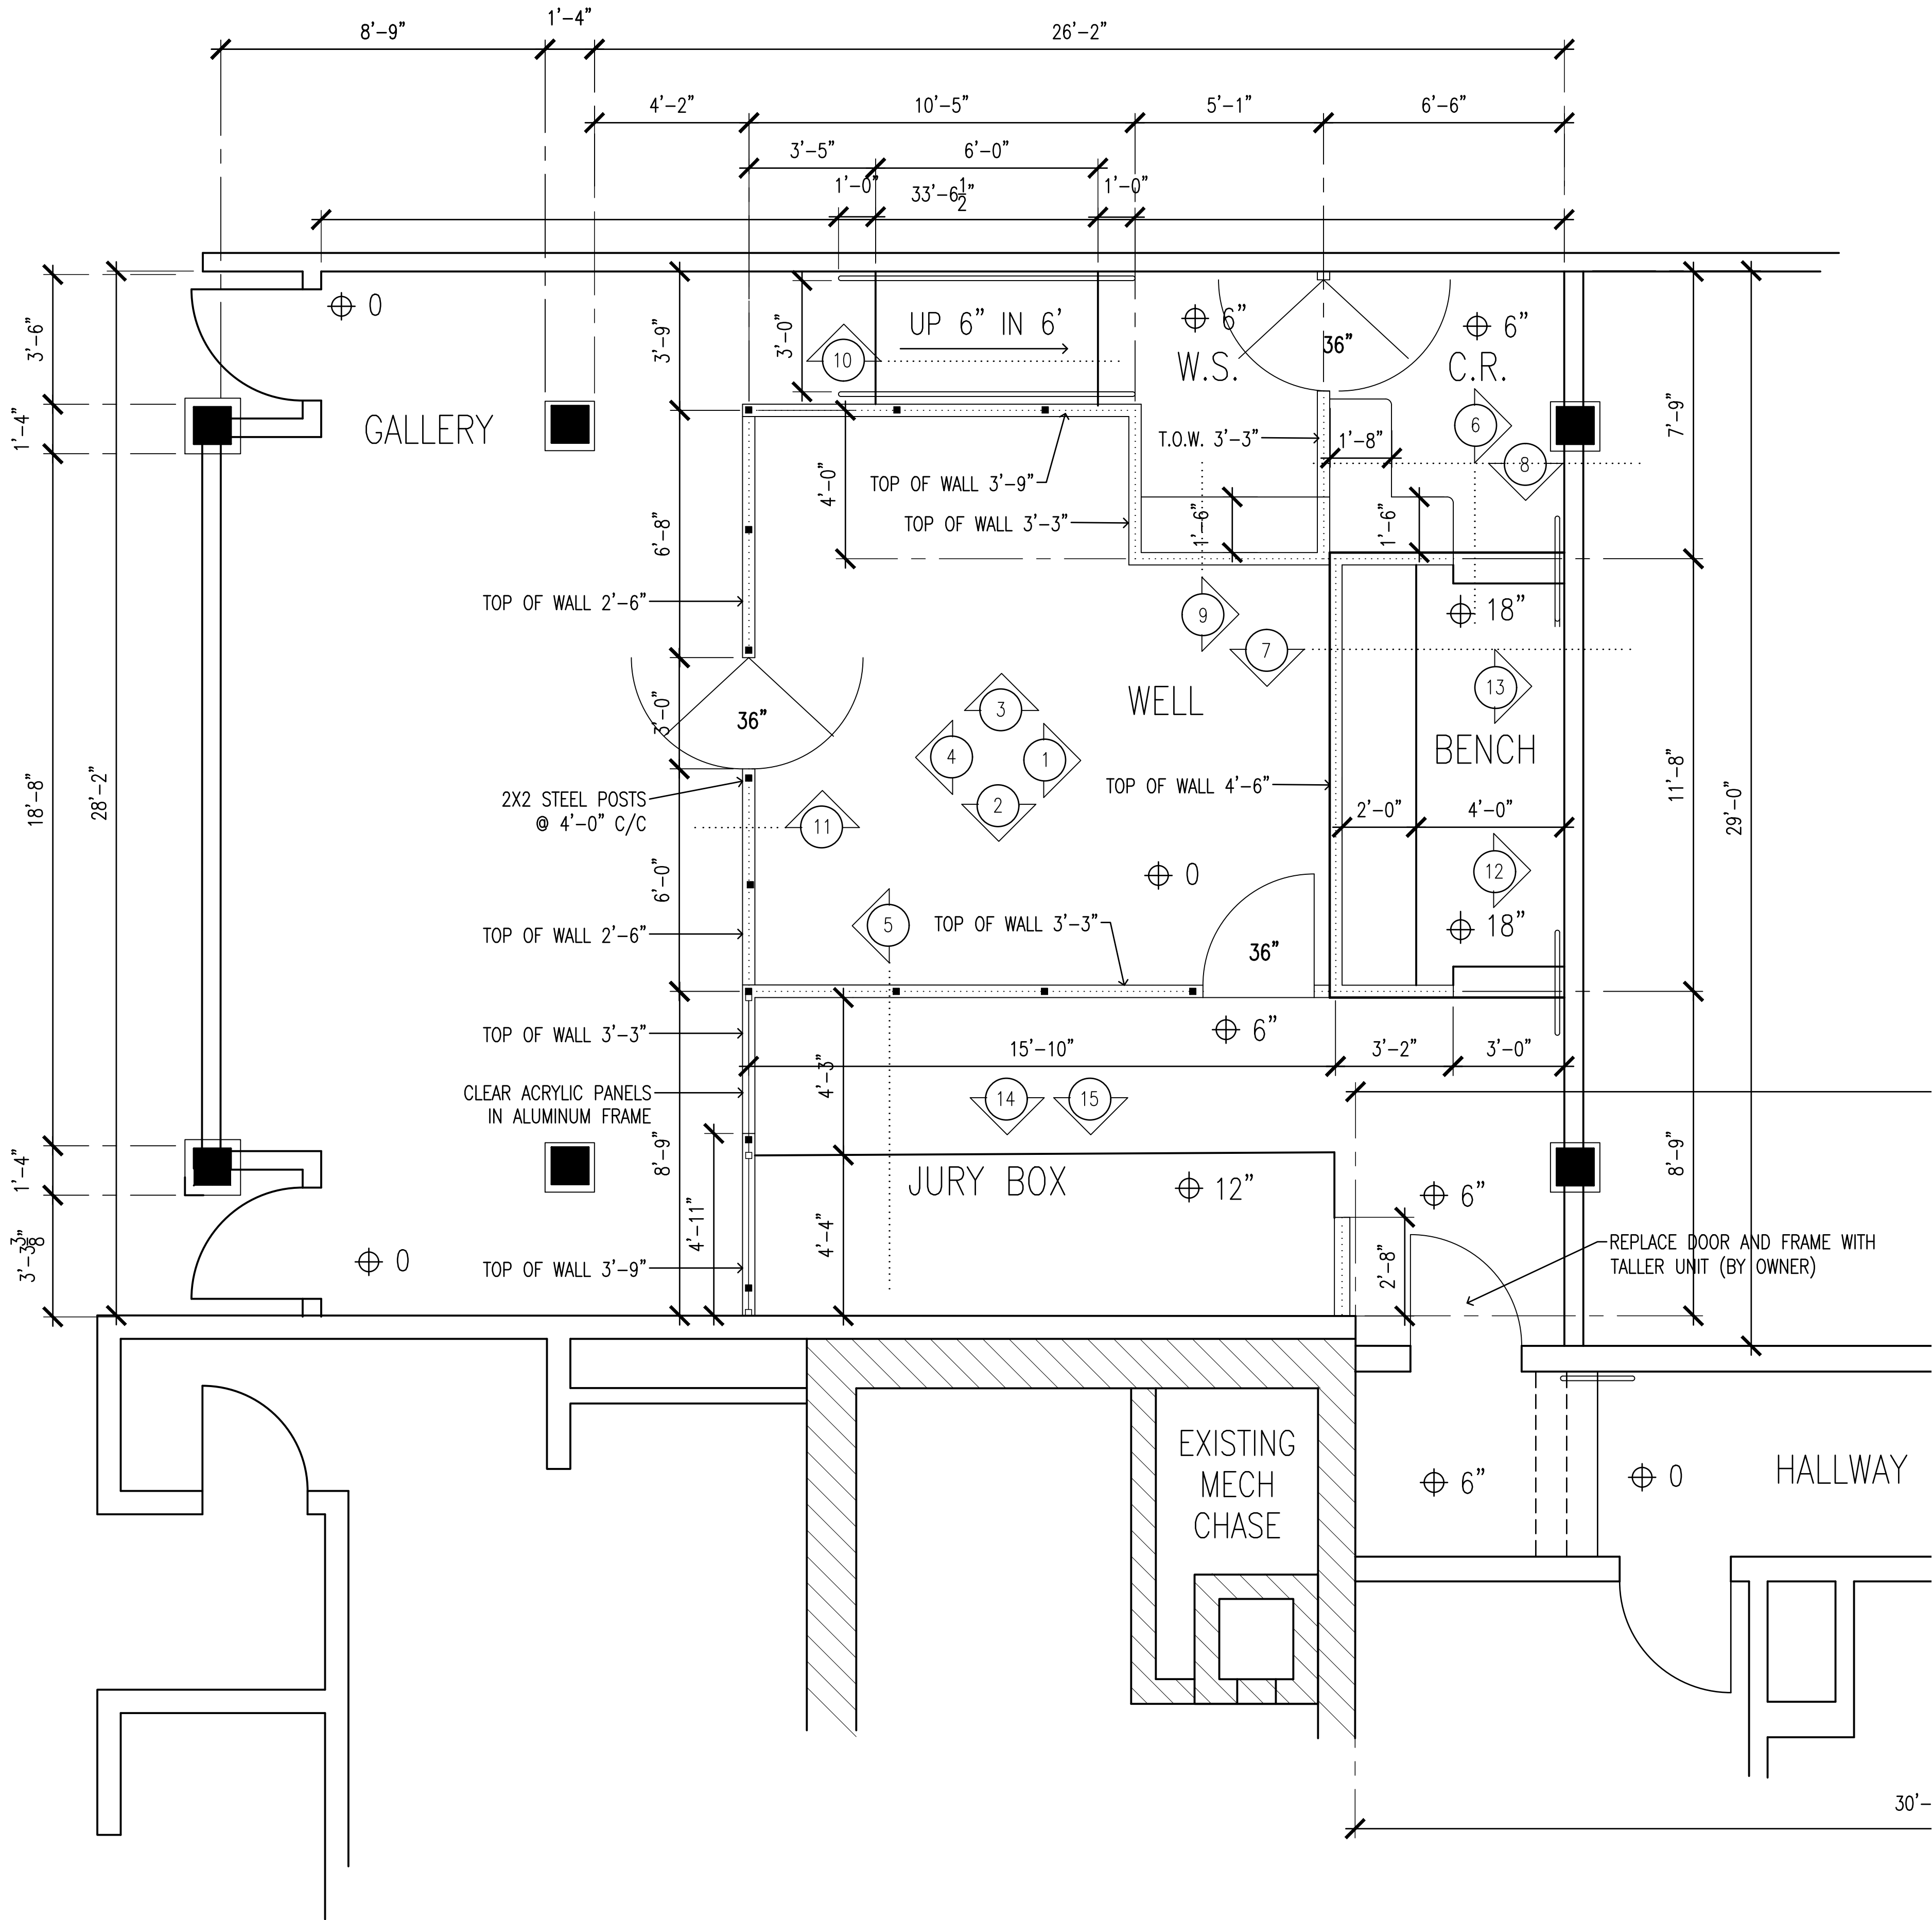

DIMENSIONS ARE TAKEN FROM EXISTING
BUILDING DRAWINGS AND ARE APPROXIMATE.
FIELD VERIFY ALL CRITICAL DIMENSIONS.


DIMENSION PLAN
scale: 3/8" = 1'-0"
scale is accurate on 24"x36" sheets only

REVISIONS	BY

DRAWINGS COPYRIGHT © 2026
ALL RIGHTS RESERVED
Stephen Coker Architect LLC



Courtroom 2A Renovation
Shelby County Courthouse
112 North Main Street
Columbiana, Alabama 35051

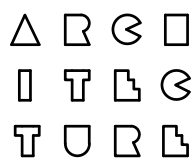

Stephen
Coker
Architect
LLC

1000 Glen View Road
Birmingham, Alabama 35222

Phone 205/595-0021

E-mail:
steve@cokerarch.com

DRAWING DATE	8-17-2026
DRAWN BY	SJC
PROJECT NO.	160816


SHEET NO.
A3
4 OF 7 SHEETS

REVISIONS	BY

DRAWINGS COPYRIGHT © 2026
ALL RIGHTS RESERVED
Stephen Coker Architect LLC



Courtroom 2A Renovation
Shelby County Courthouse
112 North Main Street
Columbiana, Alabama 35051

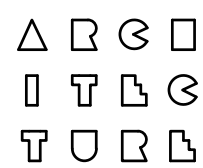

Stephen
Coker
Architect
LLC


1000 Glen View Road
Birmingham, Alabama 35222

Phone 205/595-0021

E-mail:
steve@cokerarch.com


DRAWING DATE	8-17-2026
DRAWN BY	SJC
PROJECT NO.	160816

SHEET NO.	A4
5	OF 7 SHEETS

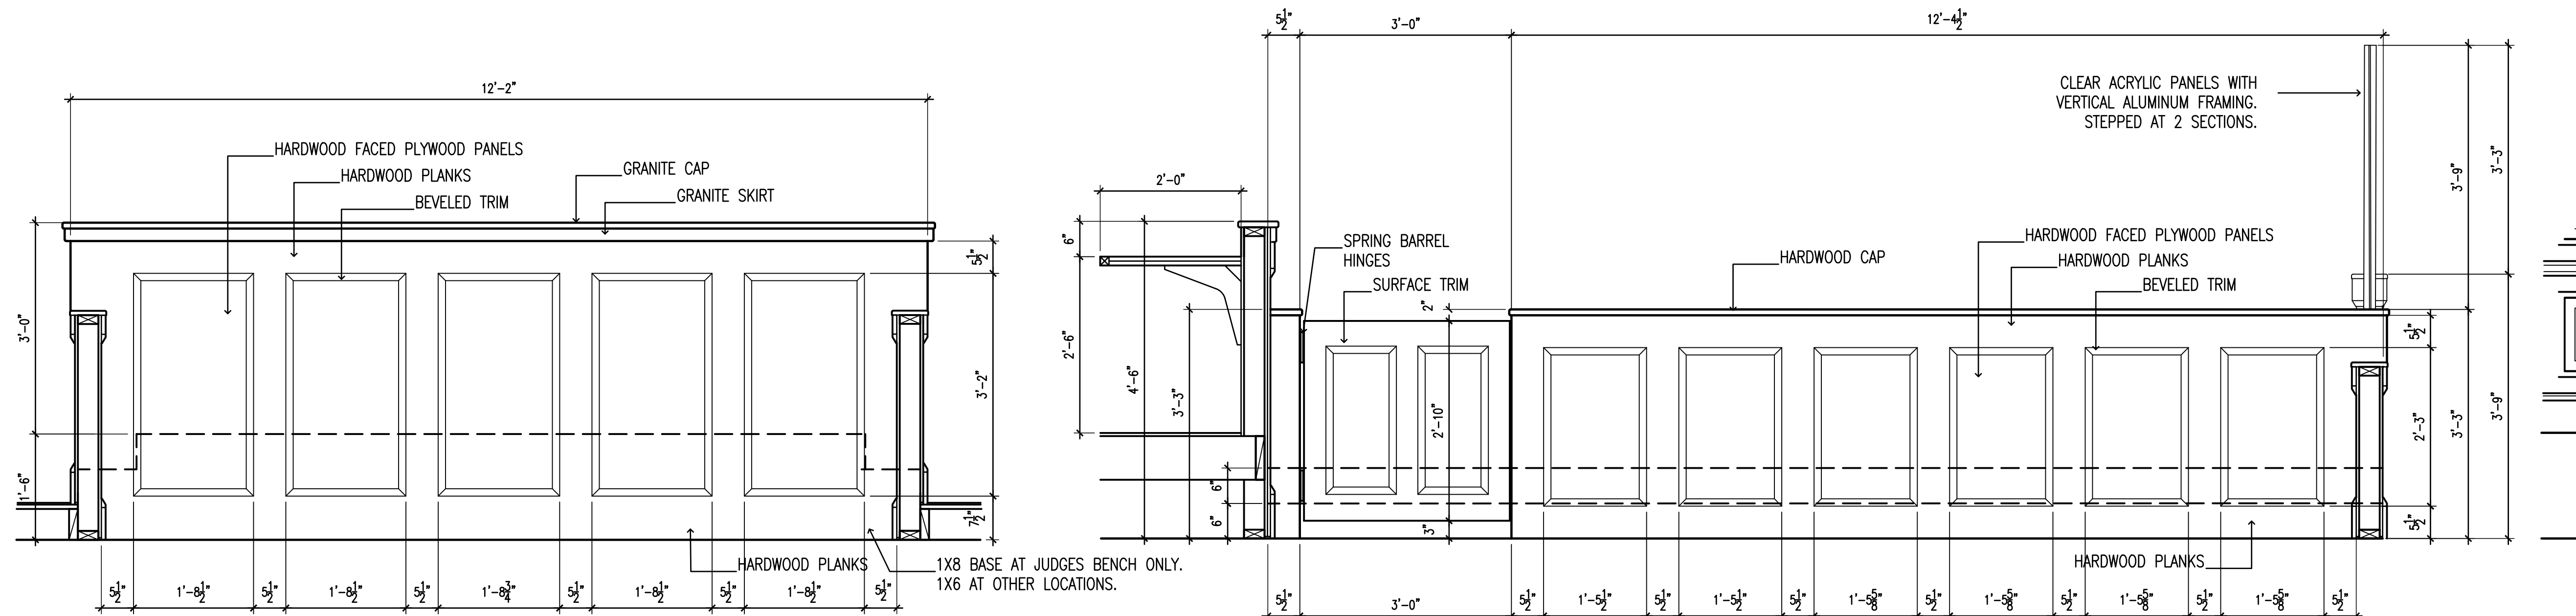


1 ELEVATION AT JUDGES BENCH


2 ELEVATION AT JURY BOX

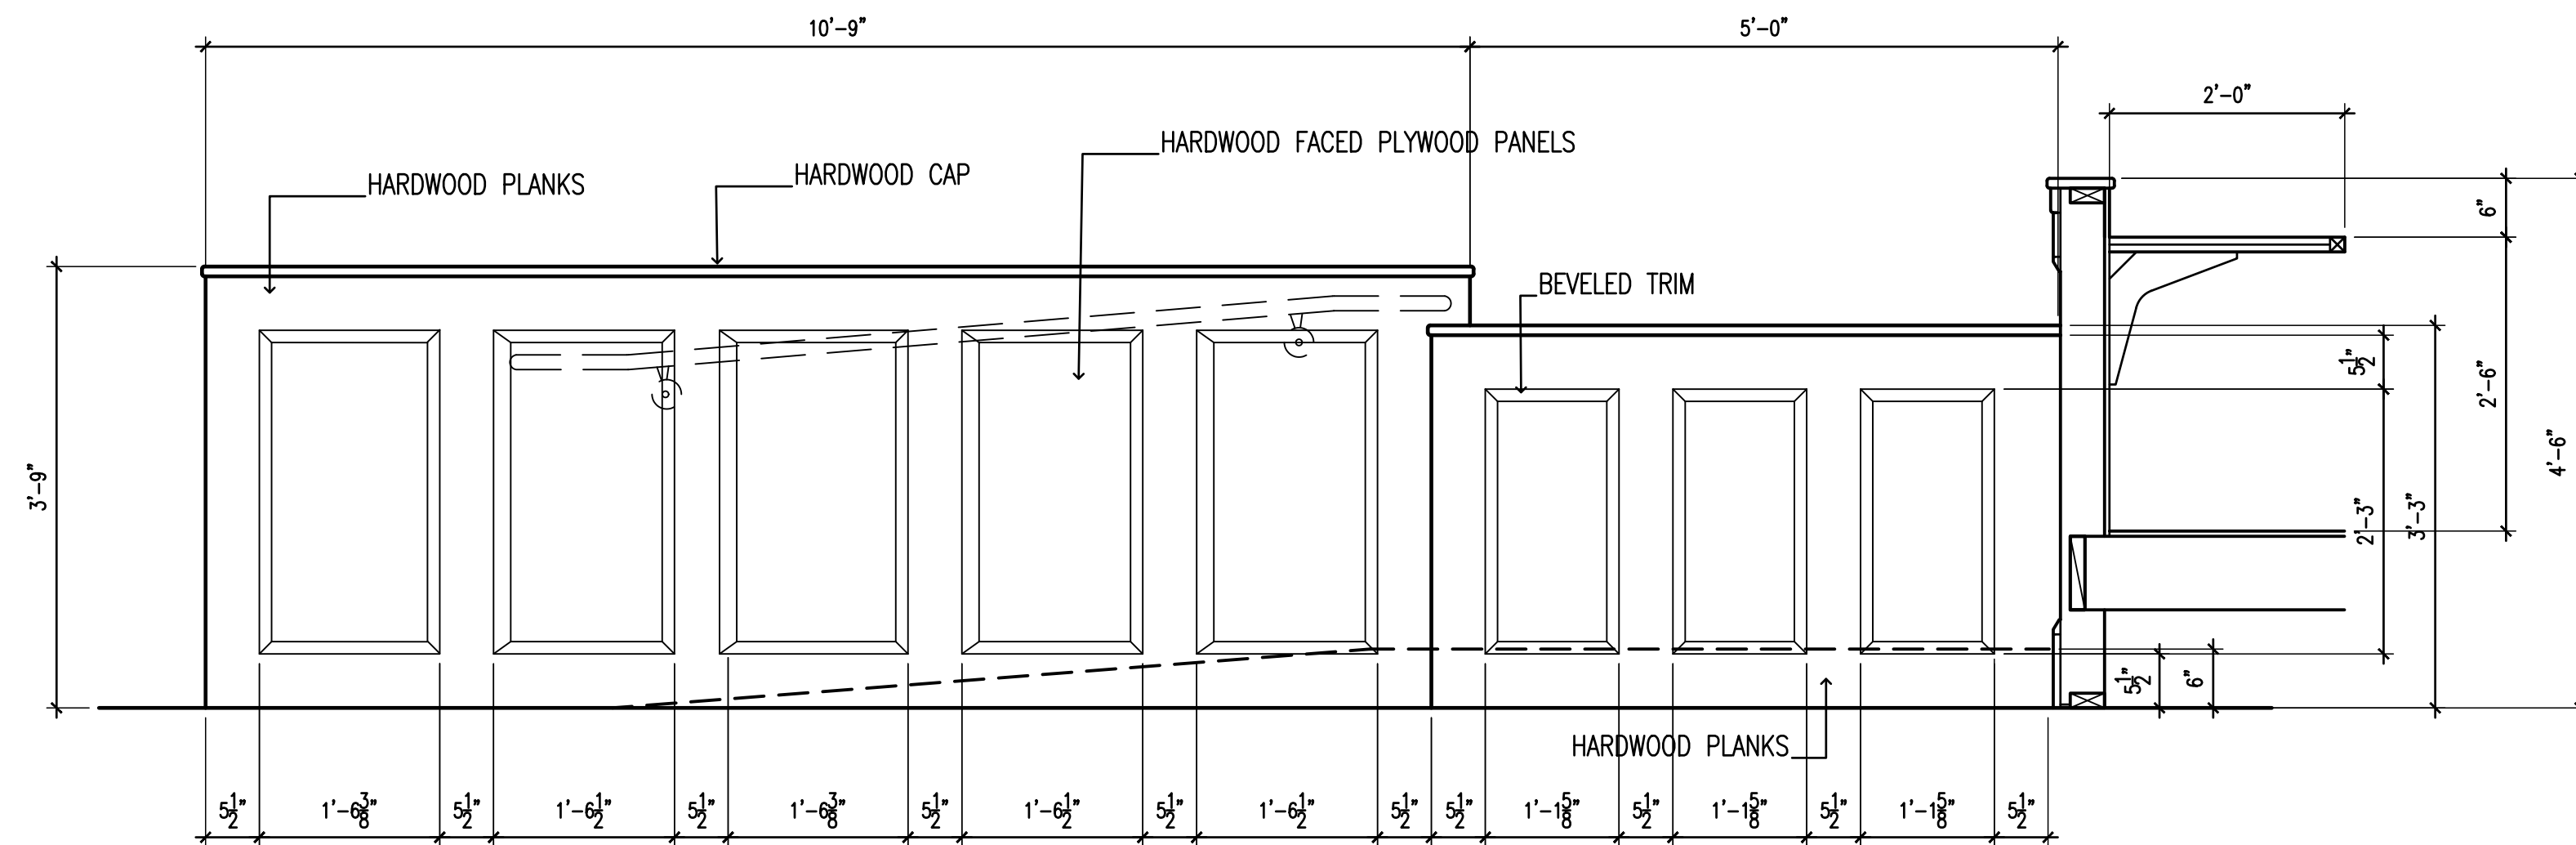

3 ELEVATION AT RAMP AND WITNESS STAND

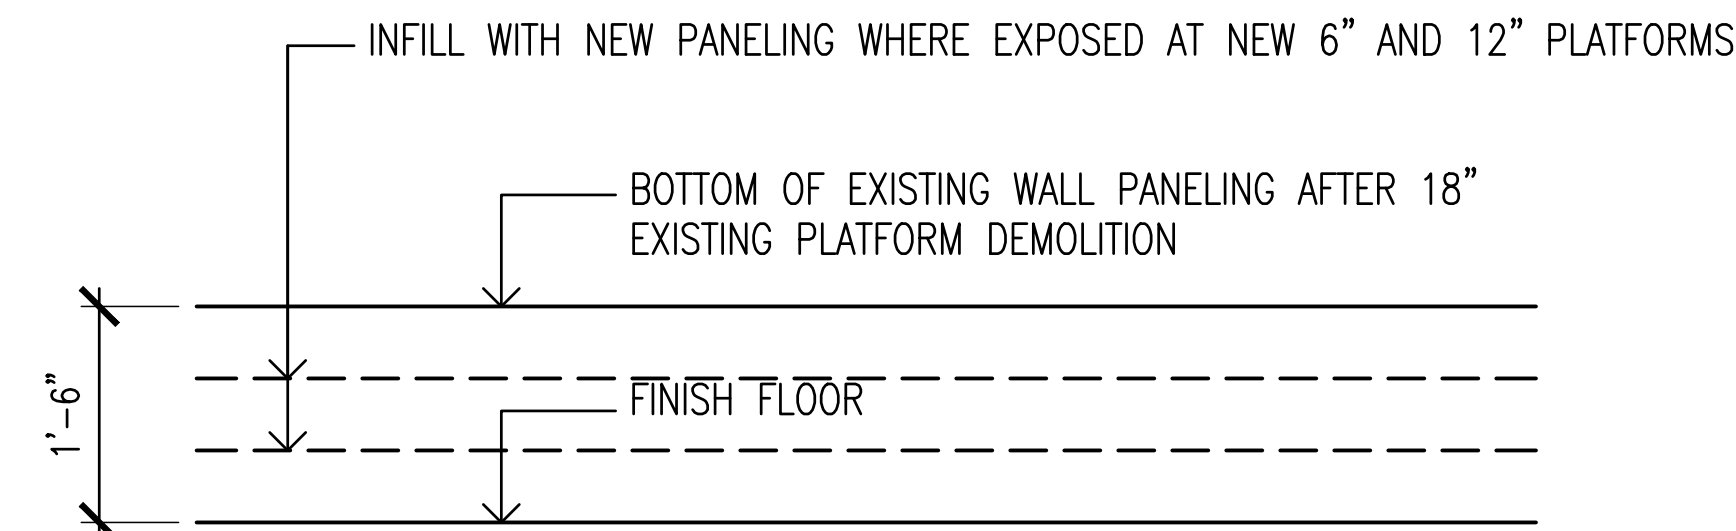

TYPICAL WOOD WALL PANELING INFILL AT FLOOR LEVEL
WHERE OCCURS AFTER EXISTING PLATFORM DEMO

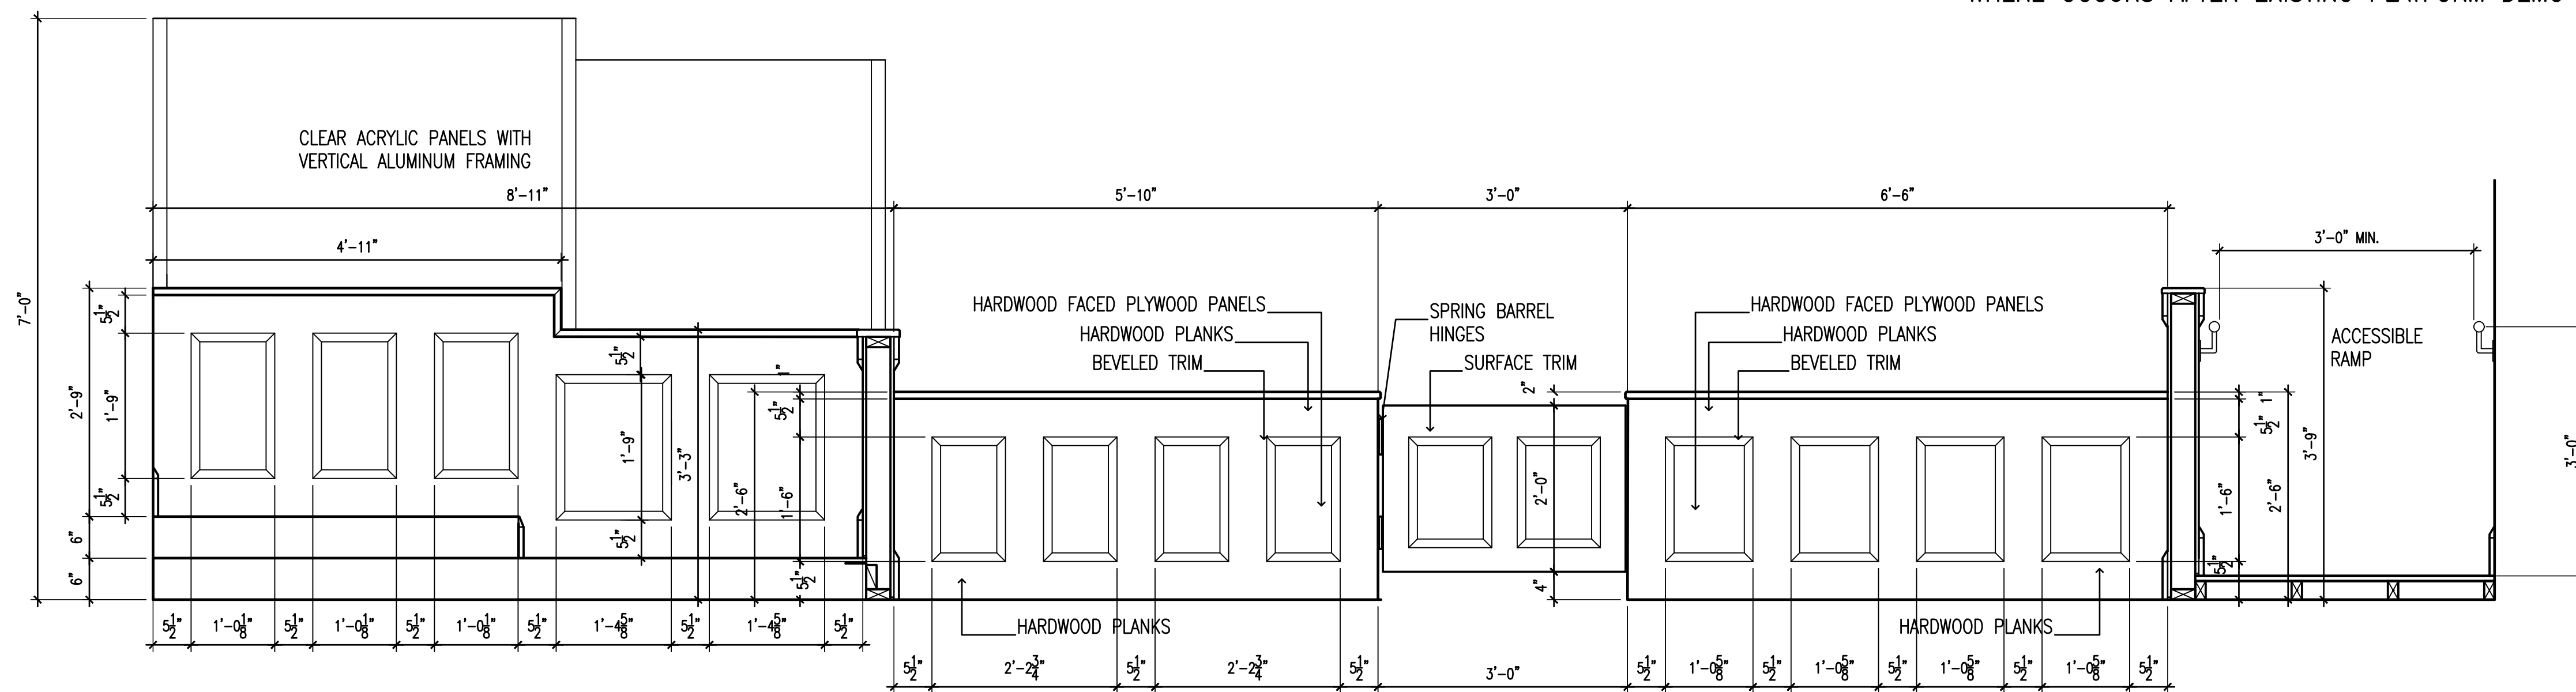

5 SECTION AT JURY BOX

4 ELEVATION AT GALLERY RAIL


COURTROOM MILLWORK DETAILS
scale: 3/4" = 1'-0"
scale is accurate on 24"x36" sheets only

REVISIONS	BY

DRAWINGS COPYRIGHT © 2026
ALL RIGHTS RESERVED
Stephen Coker Architect LLC



**Courtroom 2A Renovation
Shelby County Courthouse
112 North Main Street
Columbiana, Alabama 35051**

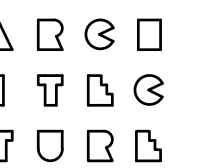

Stephen
Coker
Architect
LLC

1000 Glen View Road
Birmingham, Alabama 35222

Phone 205/595-0021



E-mail:
teve@cokerarch.com

DRAWING DATE	8-17-2026
DRAWN BY	SJC
PROJECT NO.	160816

SHEET NO.

A5

OF 7 SHEETS

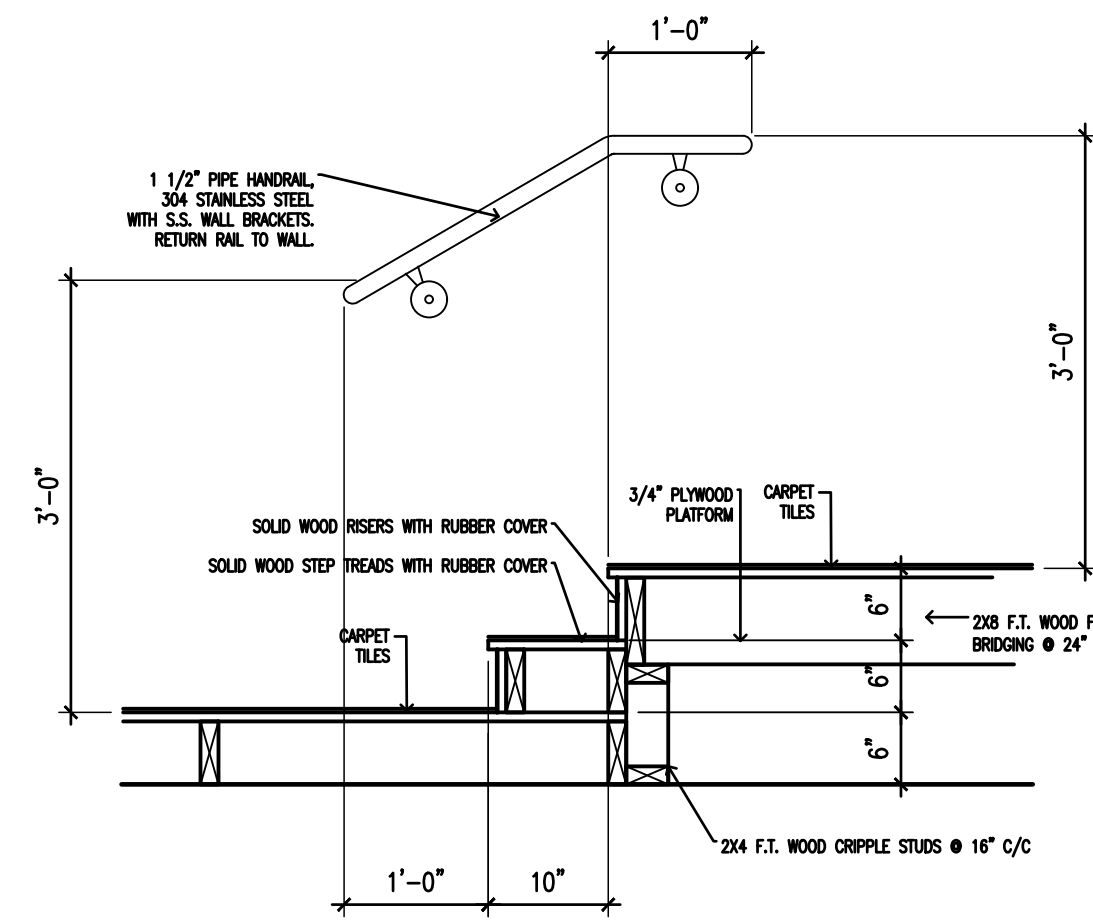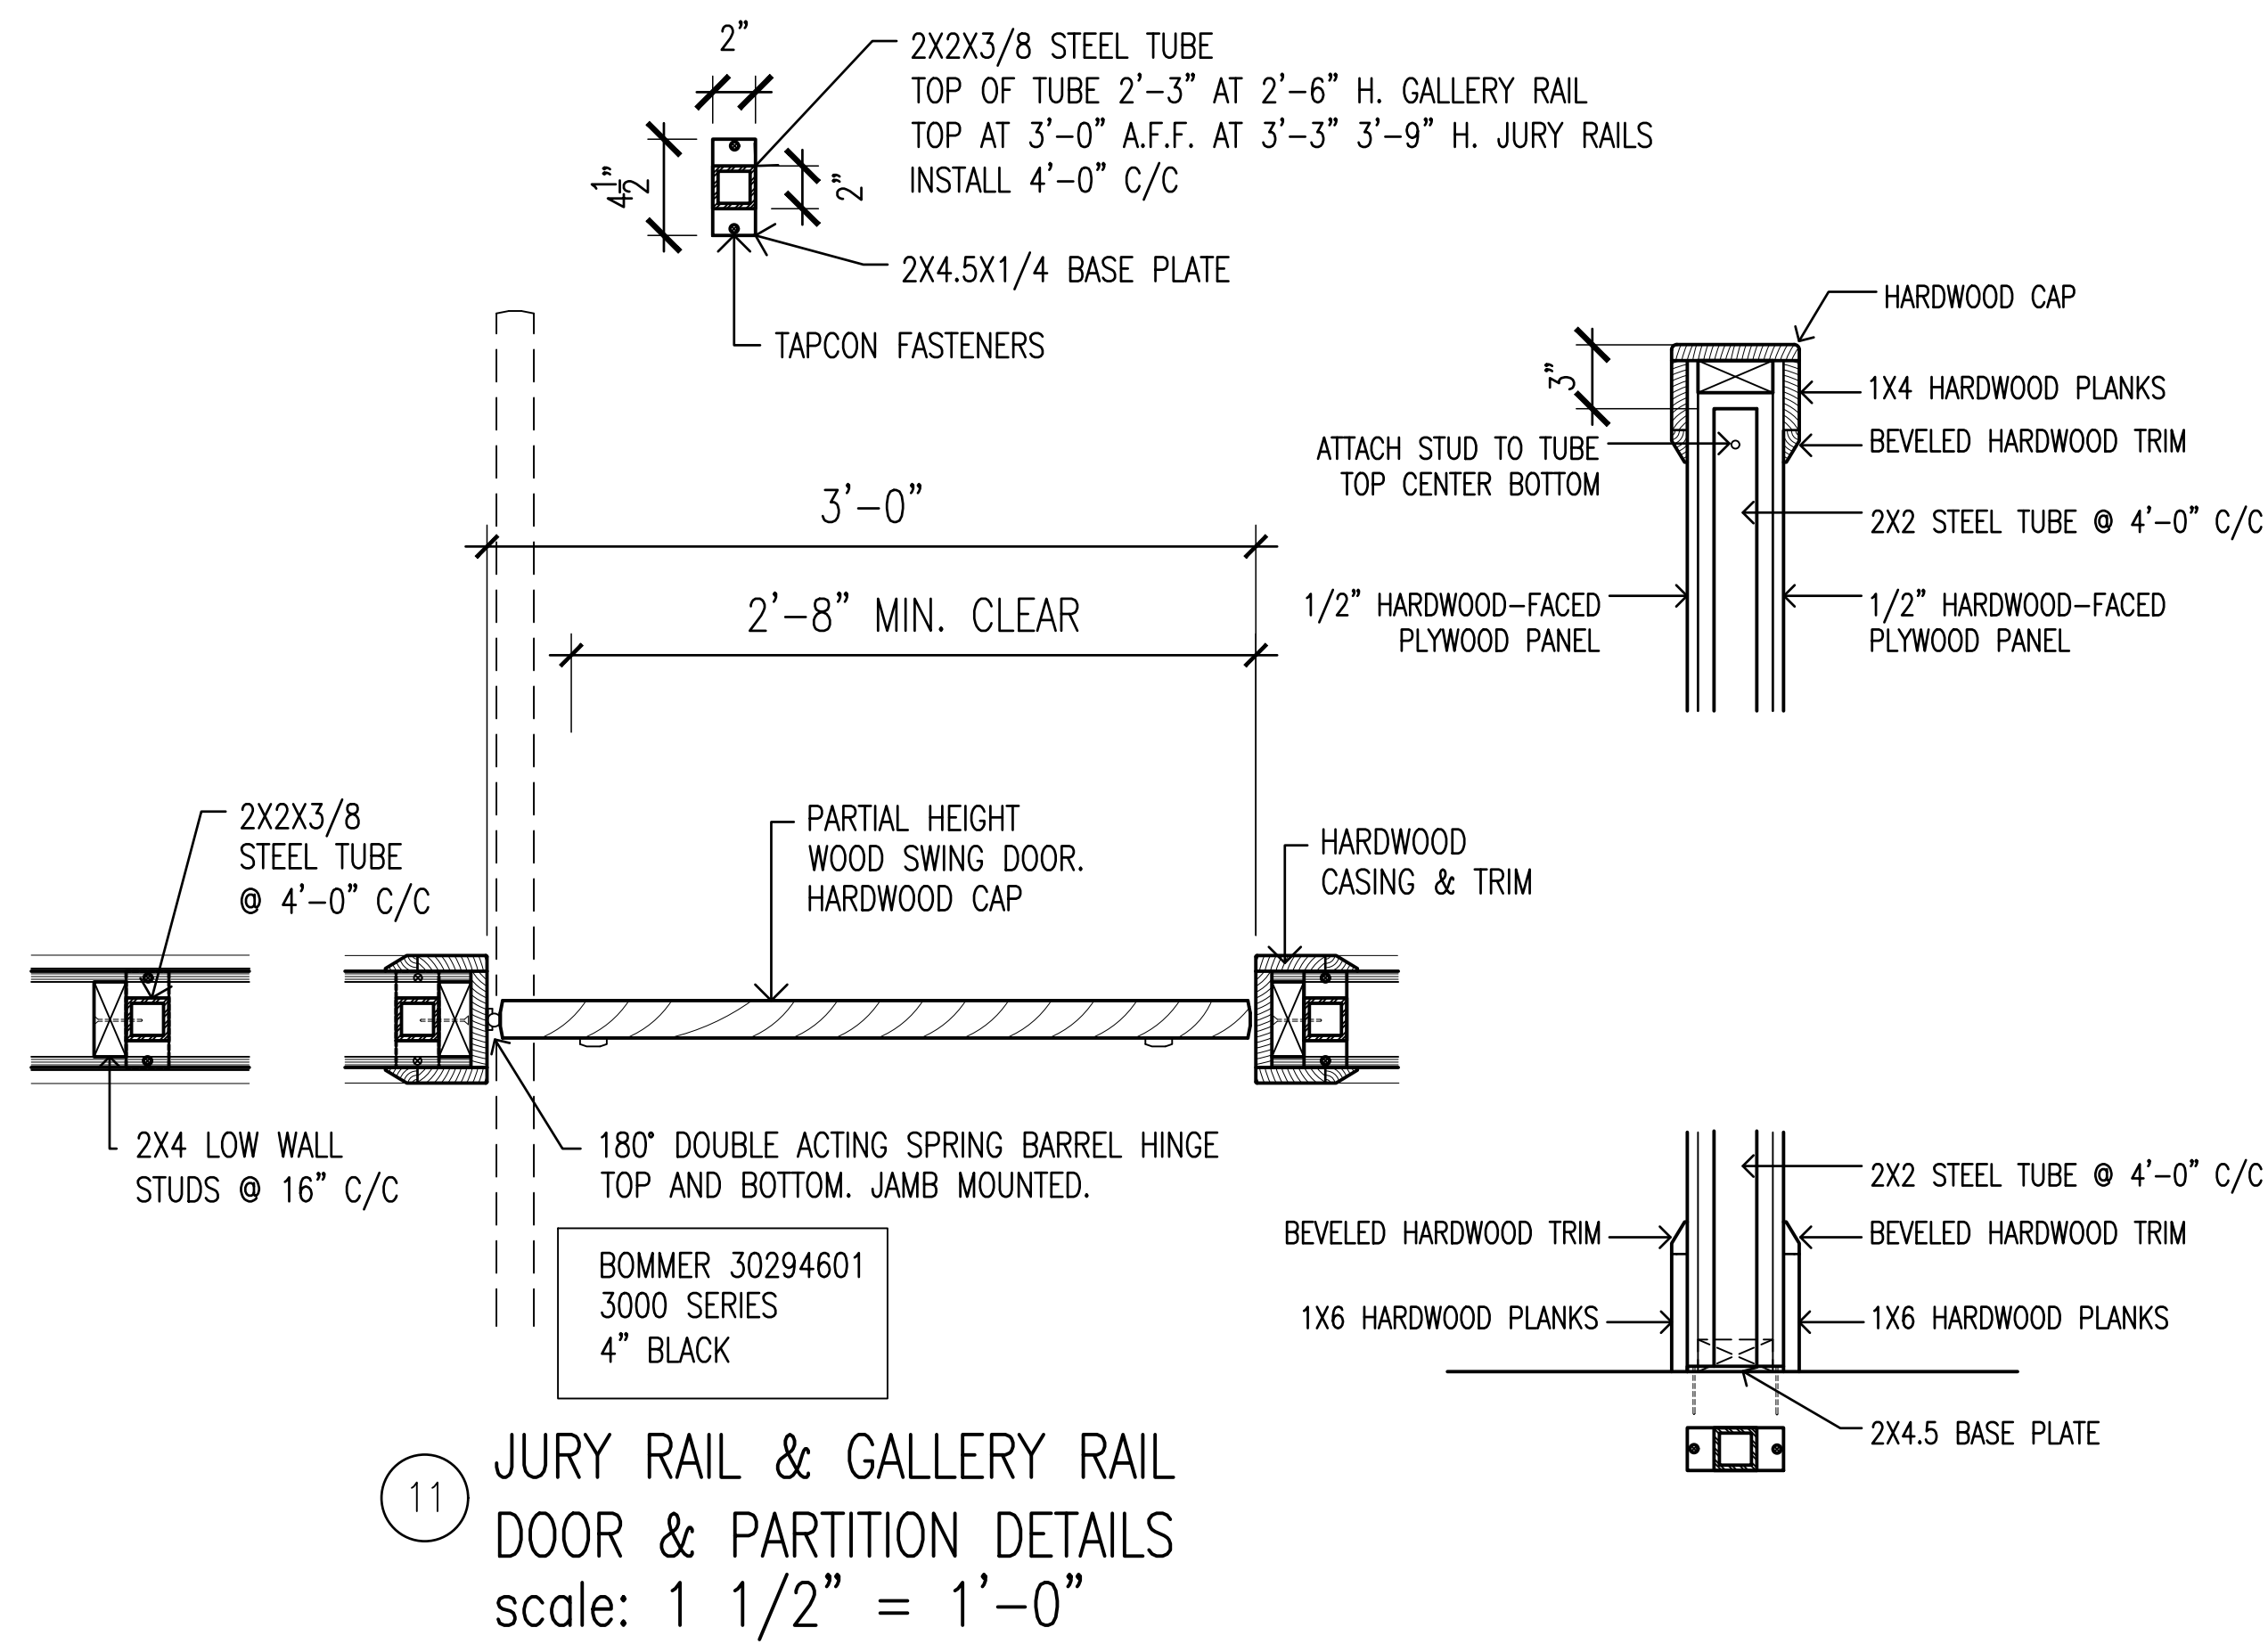


6 STAIR DETAILS AT JUDGE'S BENCH

ALL WOOD PLATFORM FRAMING TO BE
FIRE RETARDANT TREATED (F.T.)


FILL ALL VOIDS UNDER PLATFORMS,
STEPS, RAMPS SOLID WITH MINERAL WOOL
PACKED FIBER OR BATTS

HARDWOOD PLANKS AND FACED
PLYWOOD TO BE STAINED TO
MATCH EXISTING MAHOGANY WALL PANELING

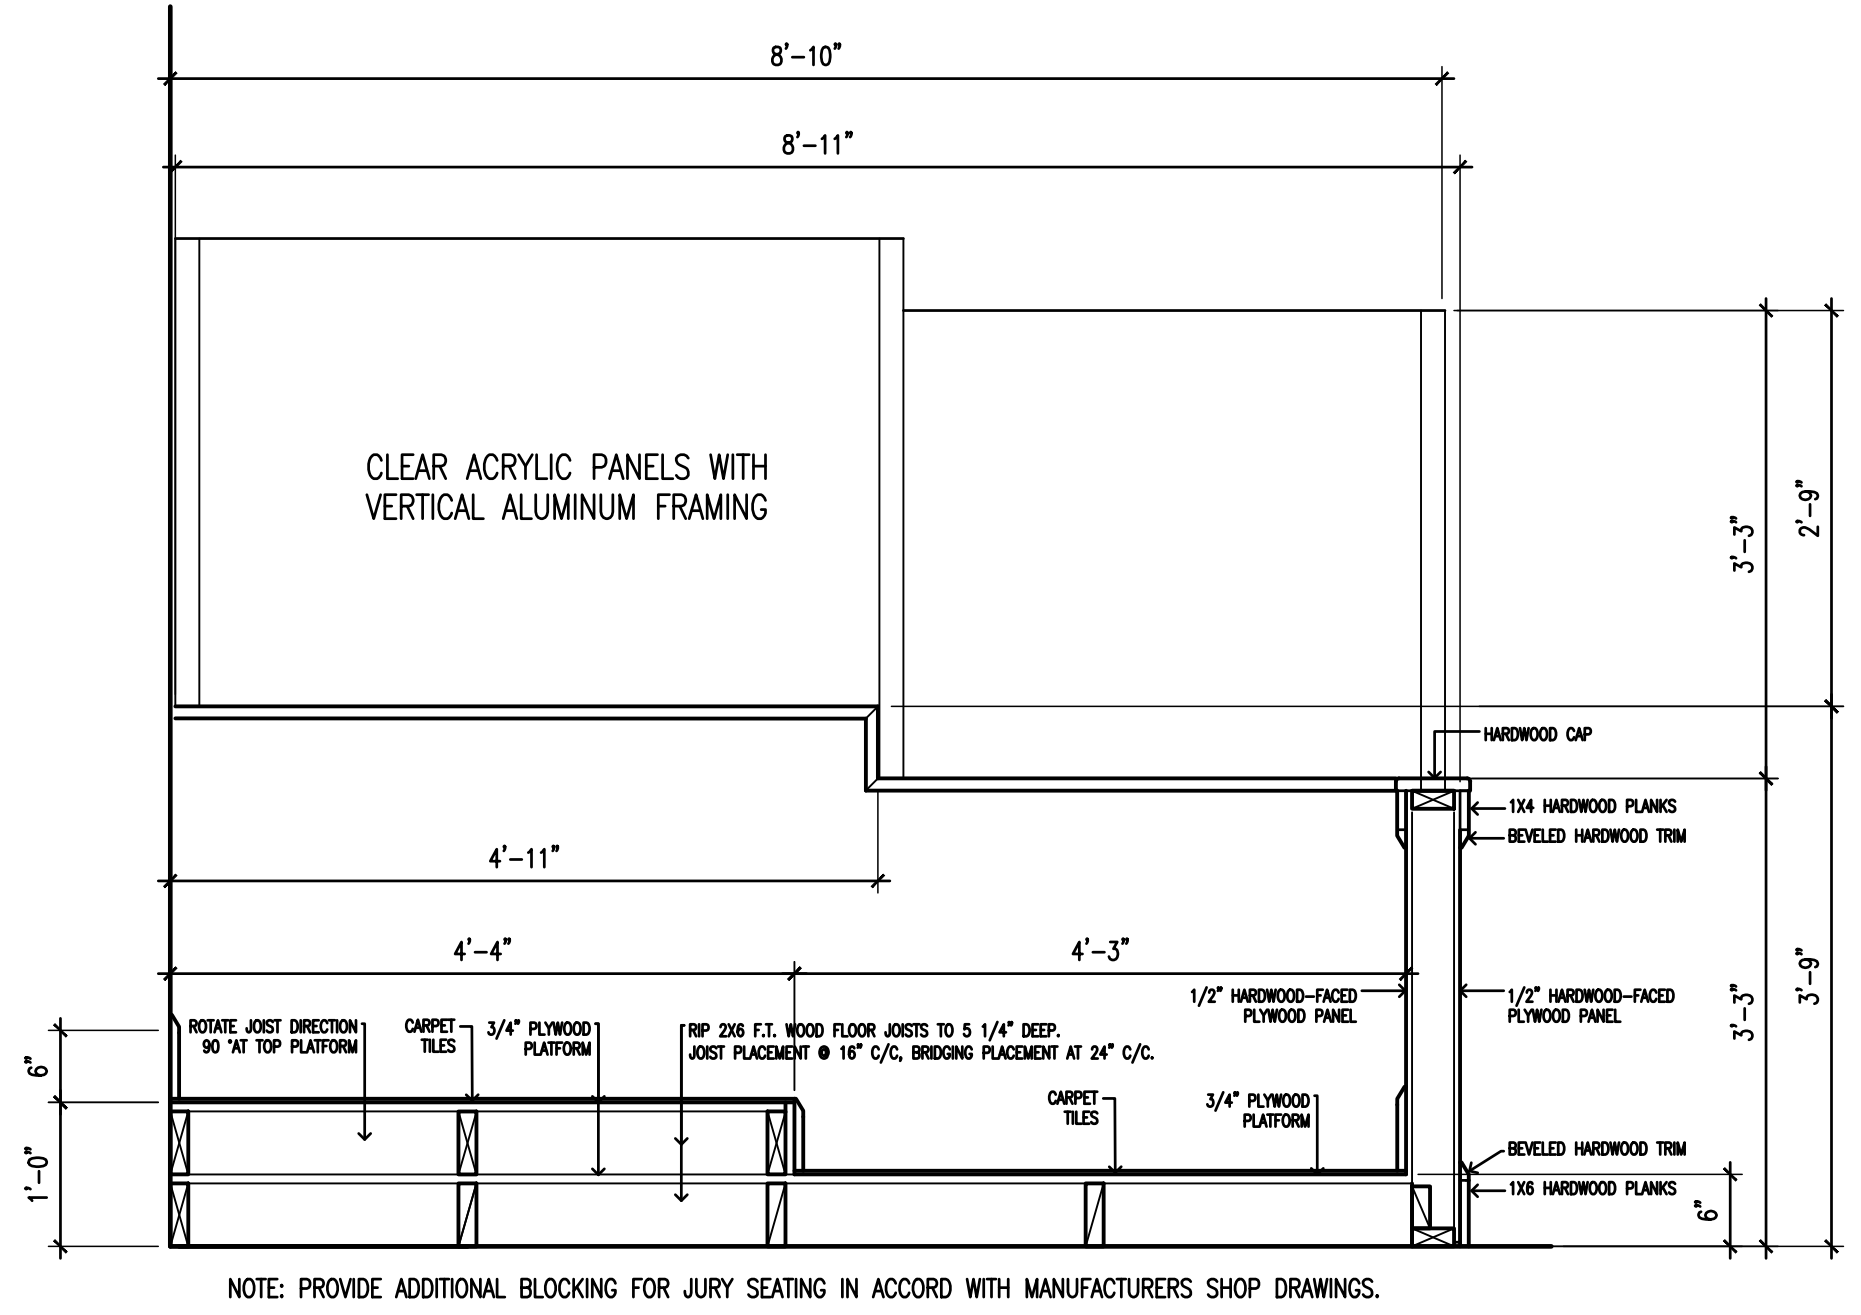


5 FLOOR SECTION AT JURY BOX


PLATFORM DETAILS
scale: 3/4" = 1'-0"

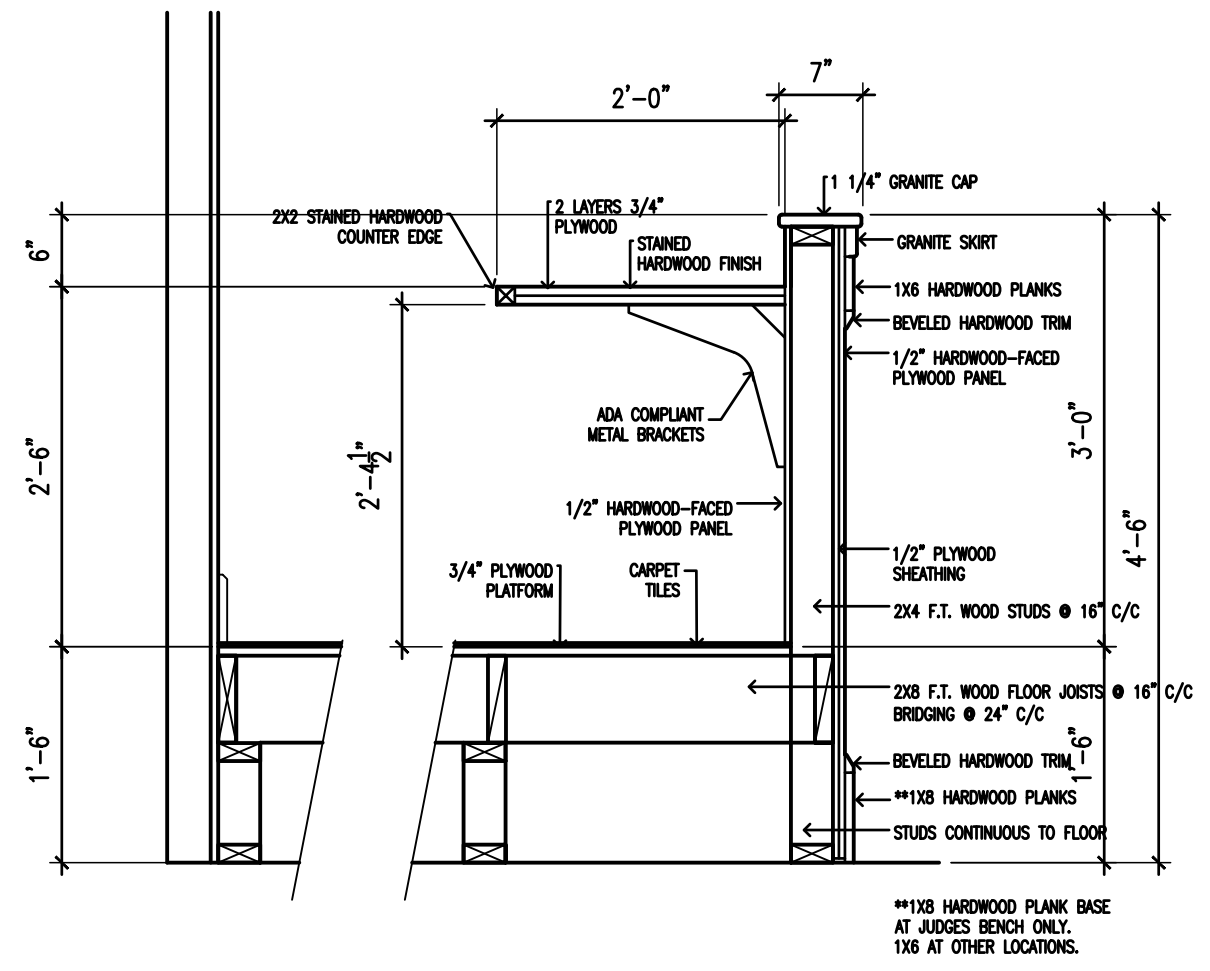


7 SECTION AT JUDGE BENCH

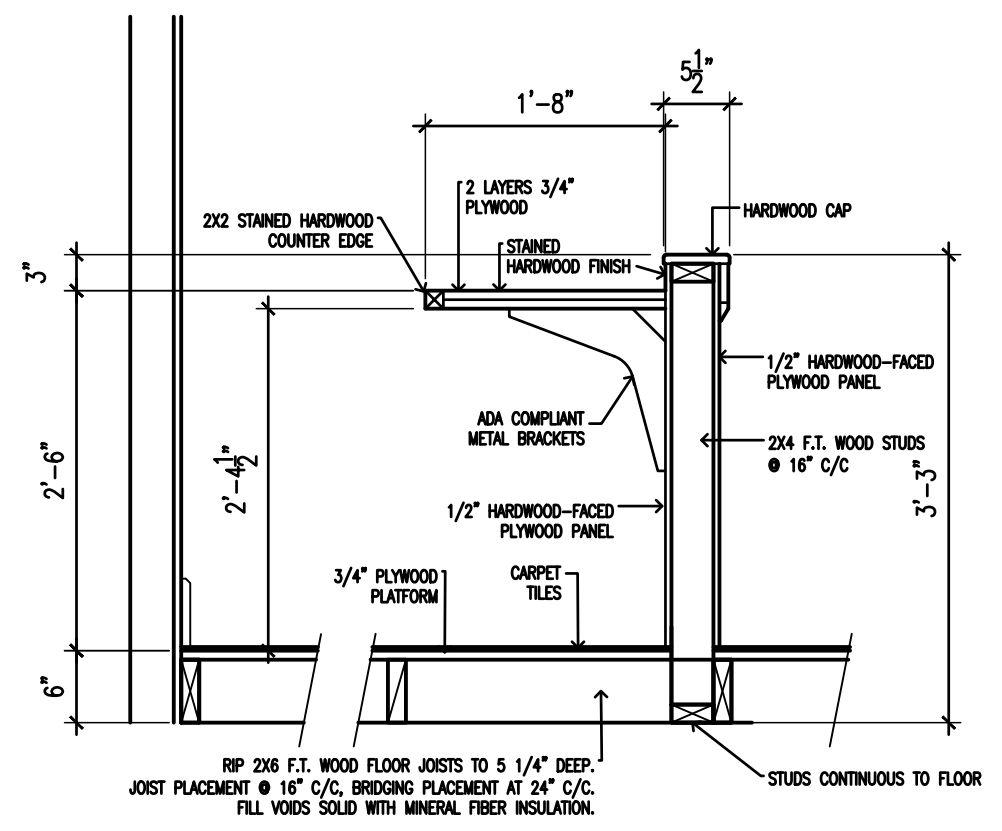


8 SECTION AT COURT REPORTER

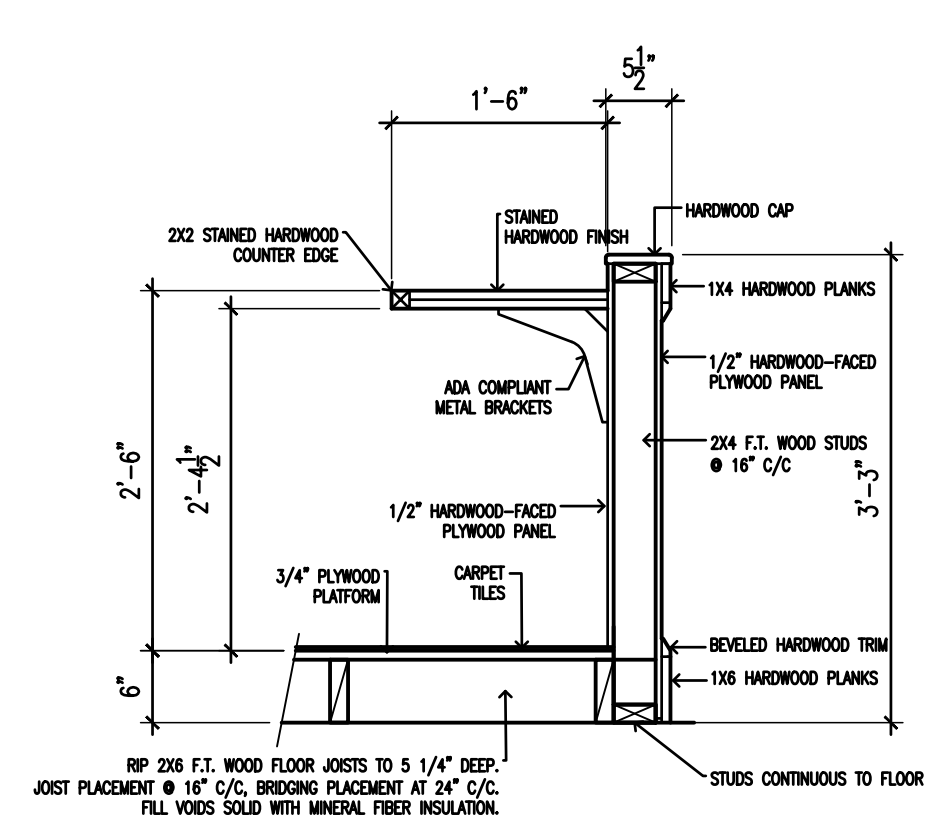


9 SECTION AT WITNESS STAND

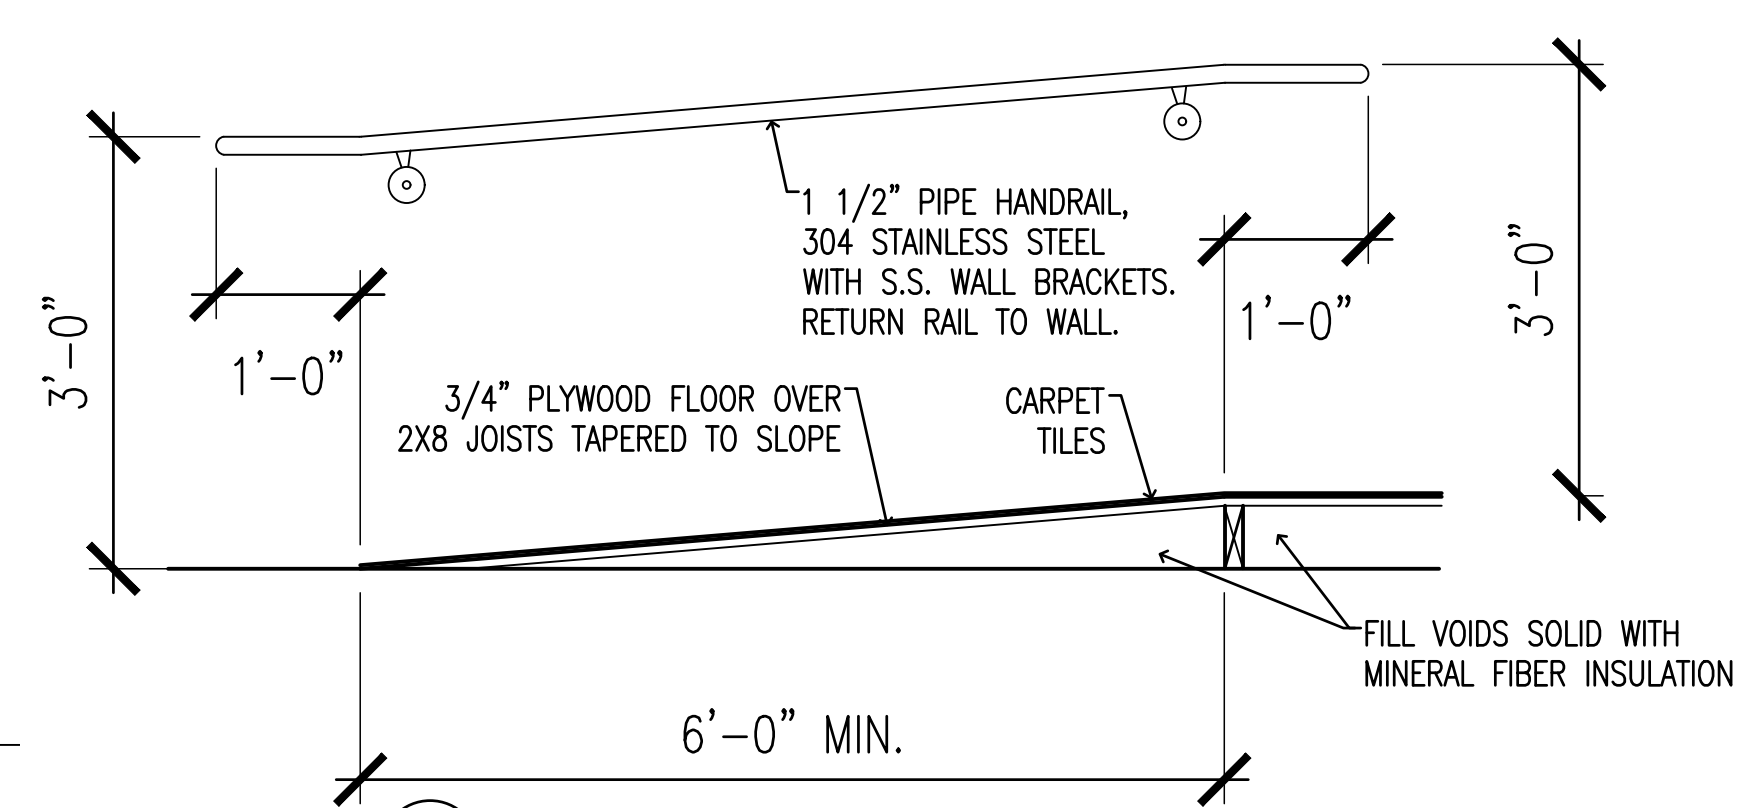


10 SECTION AT RAMP

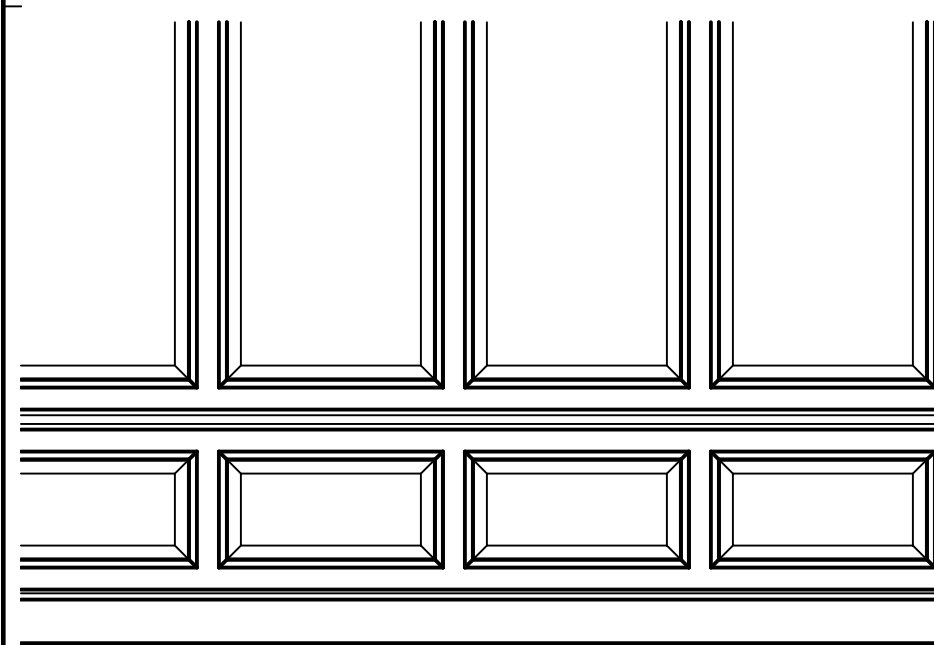


(12) EXISTING ELEVATION AT BENCH BACK WALL

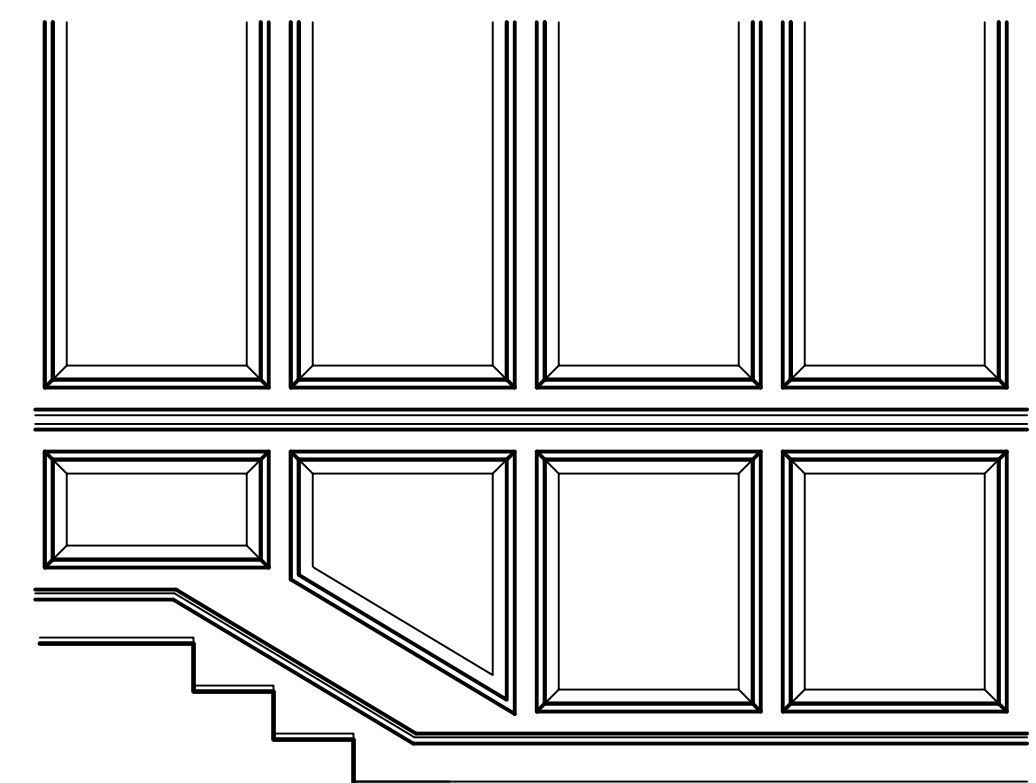

14) EXISTING ELEVATION AT NEW JURY BOX BACK WALL

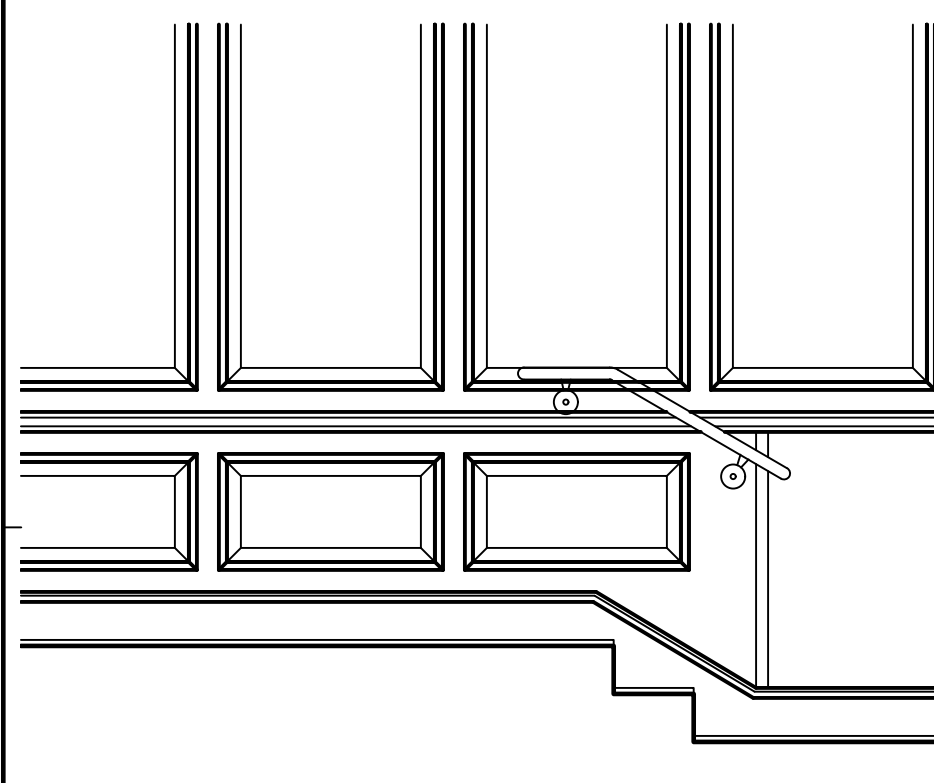

13 NEW ELEVATION AT NEW BENCH BACK WALL

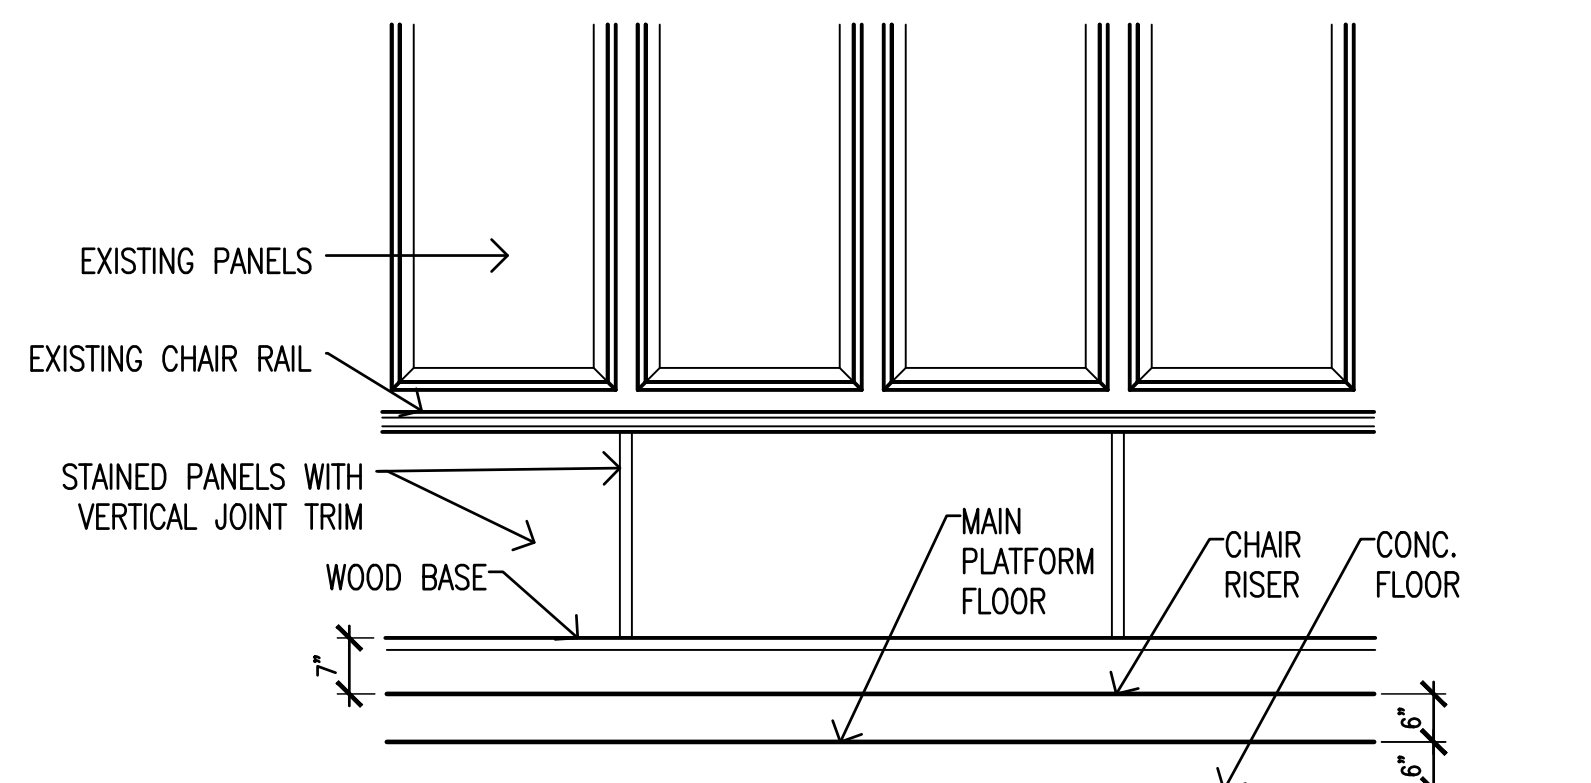

15) NEW ELEVATION AT NEW JURY BOX BACK WALL

scale: $1/2'' = 1'-0''$

COURTROOM FRAMING DETAILS


scale is accurate on 24"x36" sheets only

REVISIONS	BY

DRAWINGS COPYRIGHT © 2026
ALL RIGHTS RESERVED
Stephen Coker Architect LLC



Courtroom 2A Renovation
Shelby County Courthouse
112 North Main Street
Columbiana, Alabama 35051

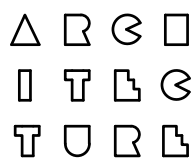

Stephen
Coker
Architect
LLC


1000 Glen View Road
Birmingham, Alabama 35222

Phone 205/595-0021

E-mail:
steve@cokerarch.com

DRAWING DATE	8-17-2026
DRAWN BY	SJC
PROJECT NO.	160816

SHEET NO.
A6
7 OF 7 SHEETS

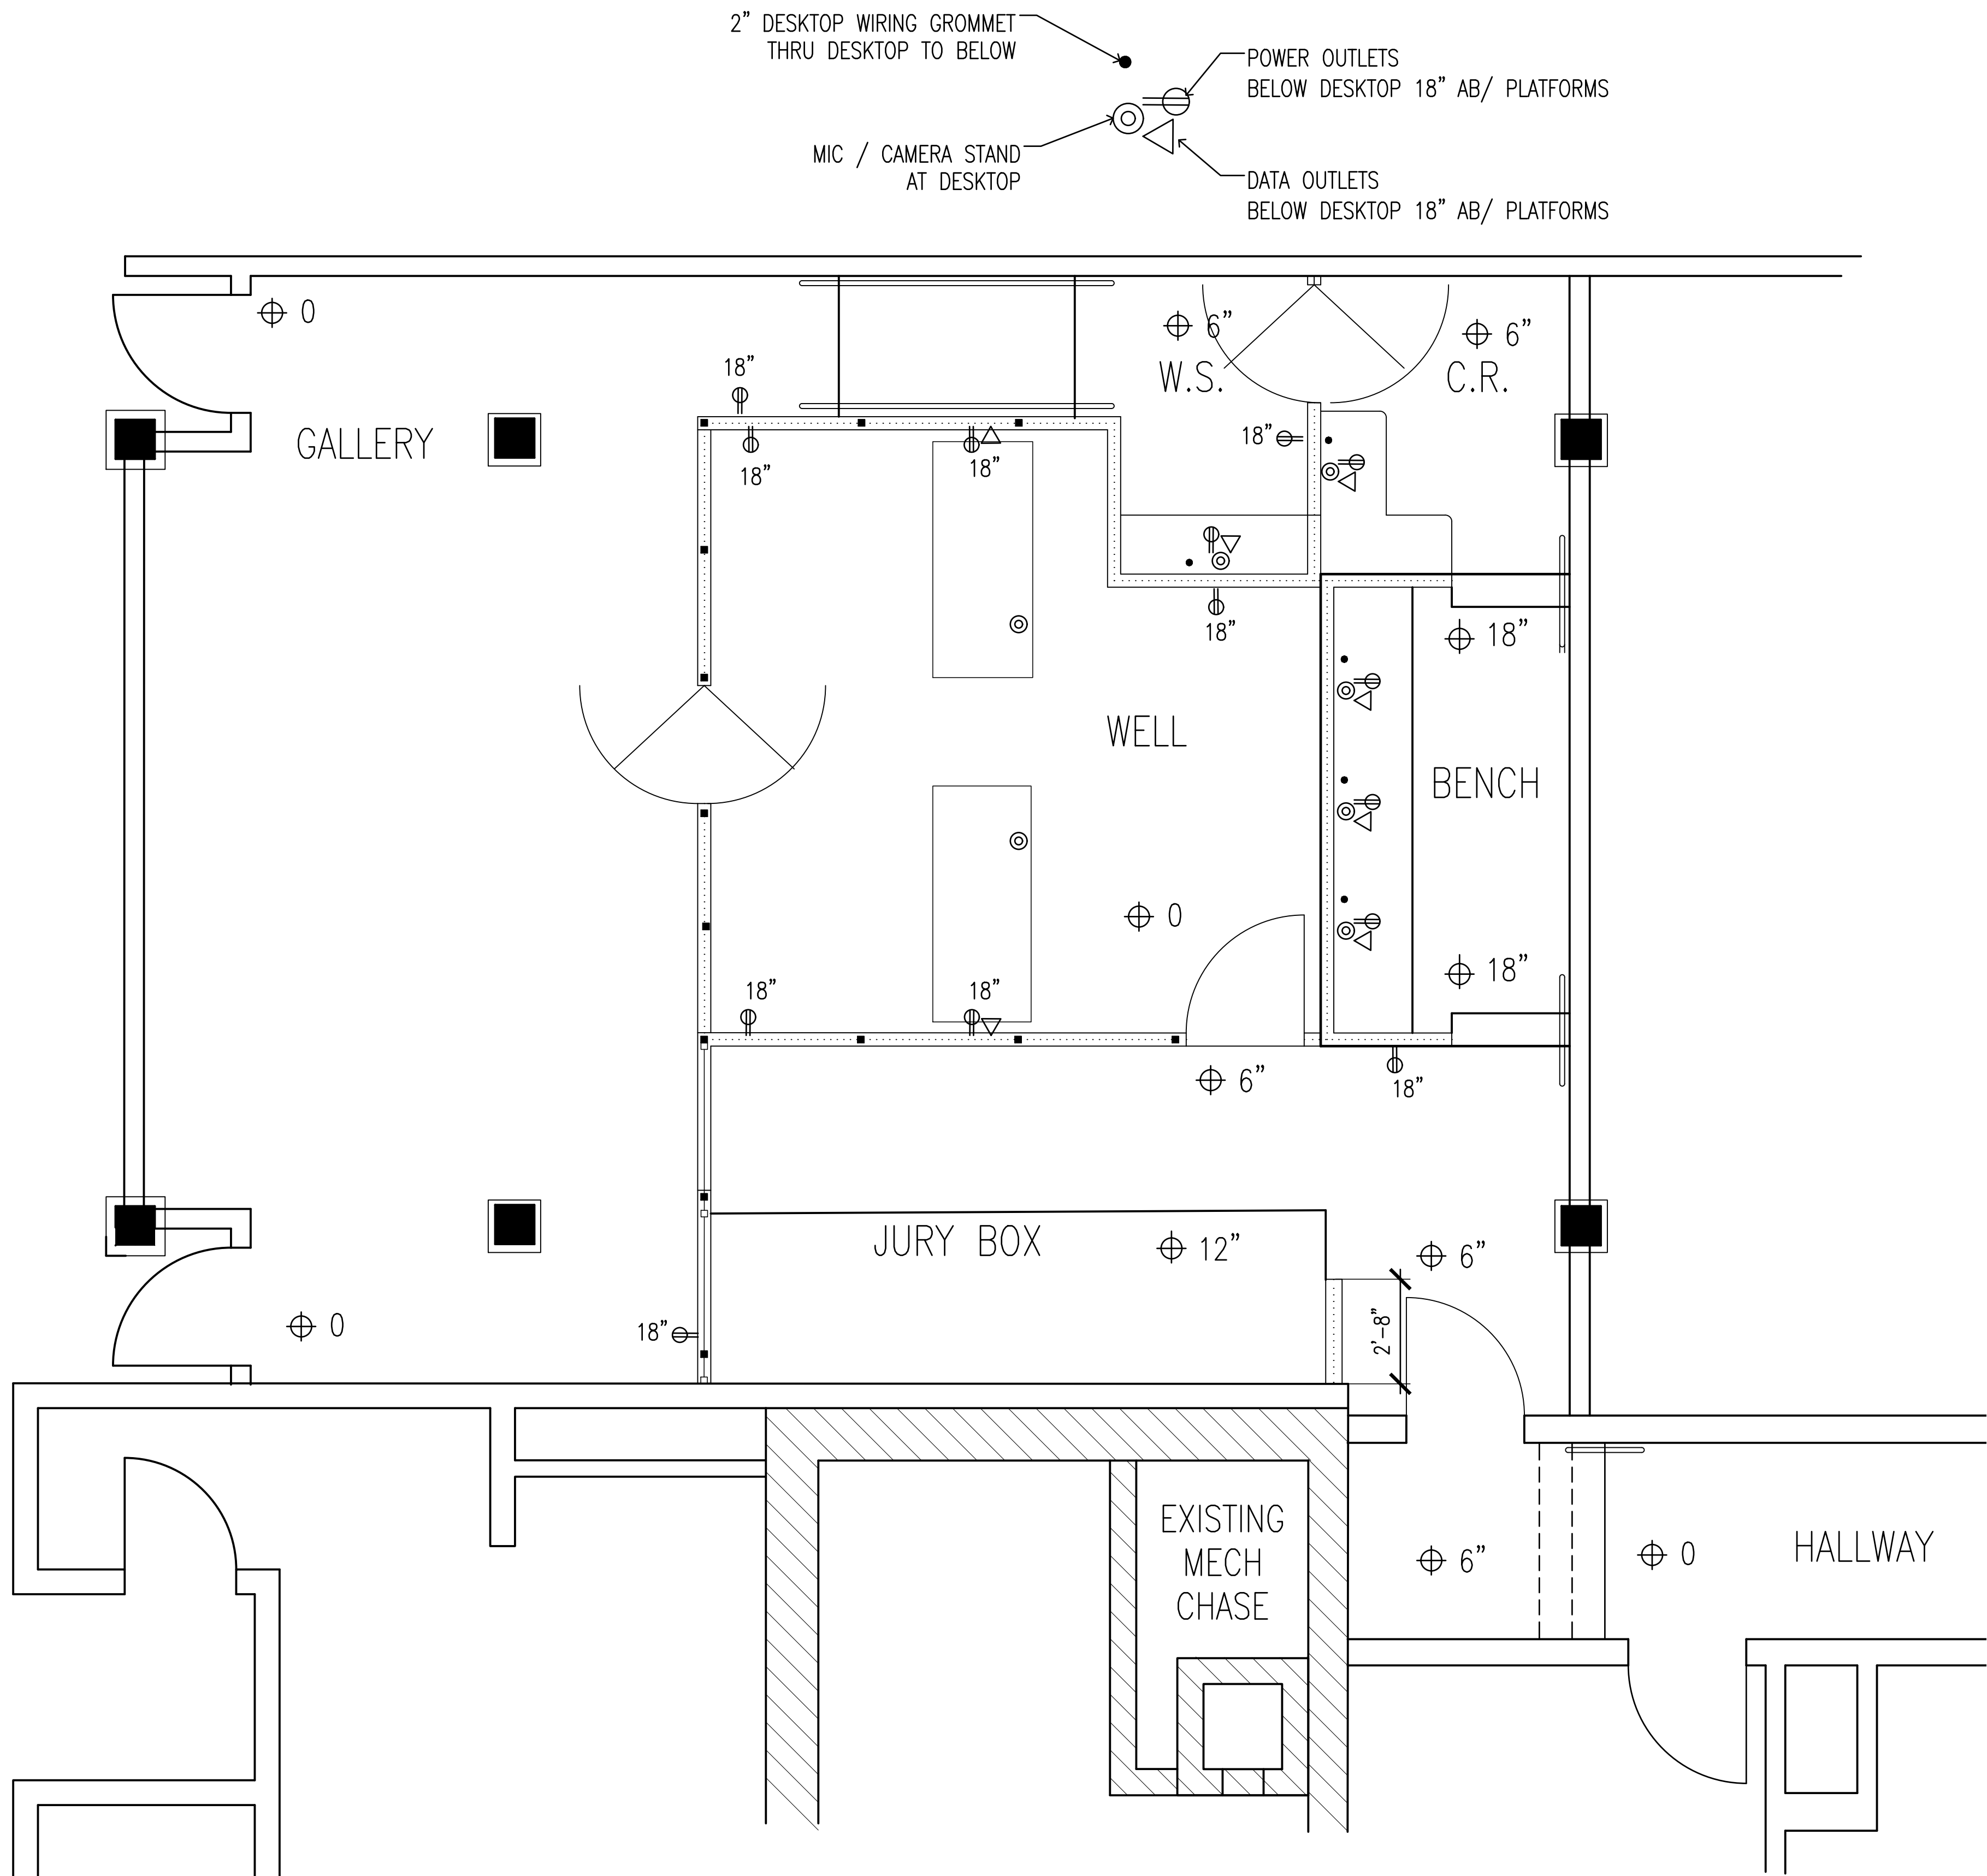

CONTRACTOR SHALL COORDINATE WITH OWNER DURING CONSTRUCTION
FOR OWNER TO PERFORM THE INSTALLATION OF POWER AND DATA.

CASEWORK SHOP DRAWINGS TO SHOW RACEWAY ROUTING TO
ACCOMMODATE POWER AND DATA AT LOCATIONS SHOWN.

PROVIDE ACCESS PANELS CUTOUTS AS REQUIRED. OWNER TO
PROVIDE FINISHED ACCESS PANELS AT CUTOUTS.

DIMENSIONS ARE TAKEN FROM EXISTING
BUILDING DRAWINGS AND ARE APPROXIMATE.
FIELD VERIFY ALL CRITICAL DIMENSIONS.

ELECTRICAL AND DATA LAYOUT
scale: 3/8" = 1'-0"
scale is accurate on 24"x36" sheets only